



VINARES GARBAGE ROOM PROPOSED
CONNECTION DRAWINGS

VINARES COMMERCIAL
ARCHITECTURAL / SERVICES DRAWING
28 FEBRUARY 2024



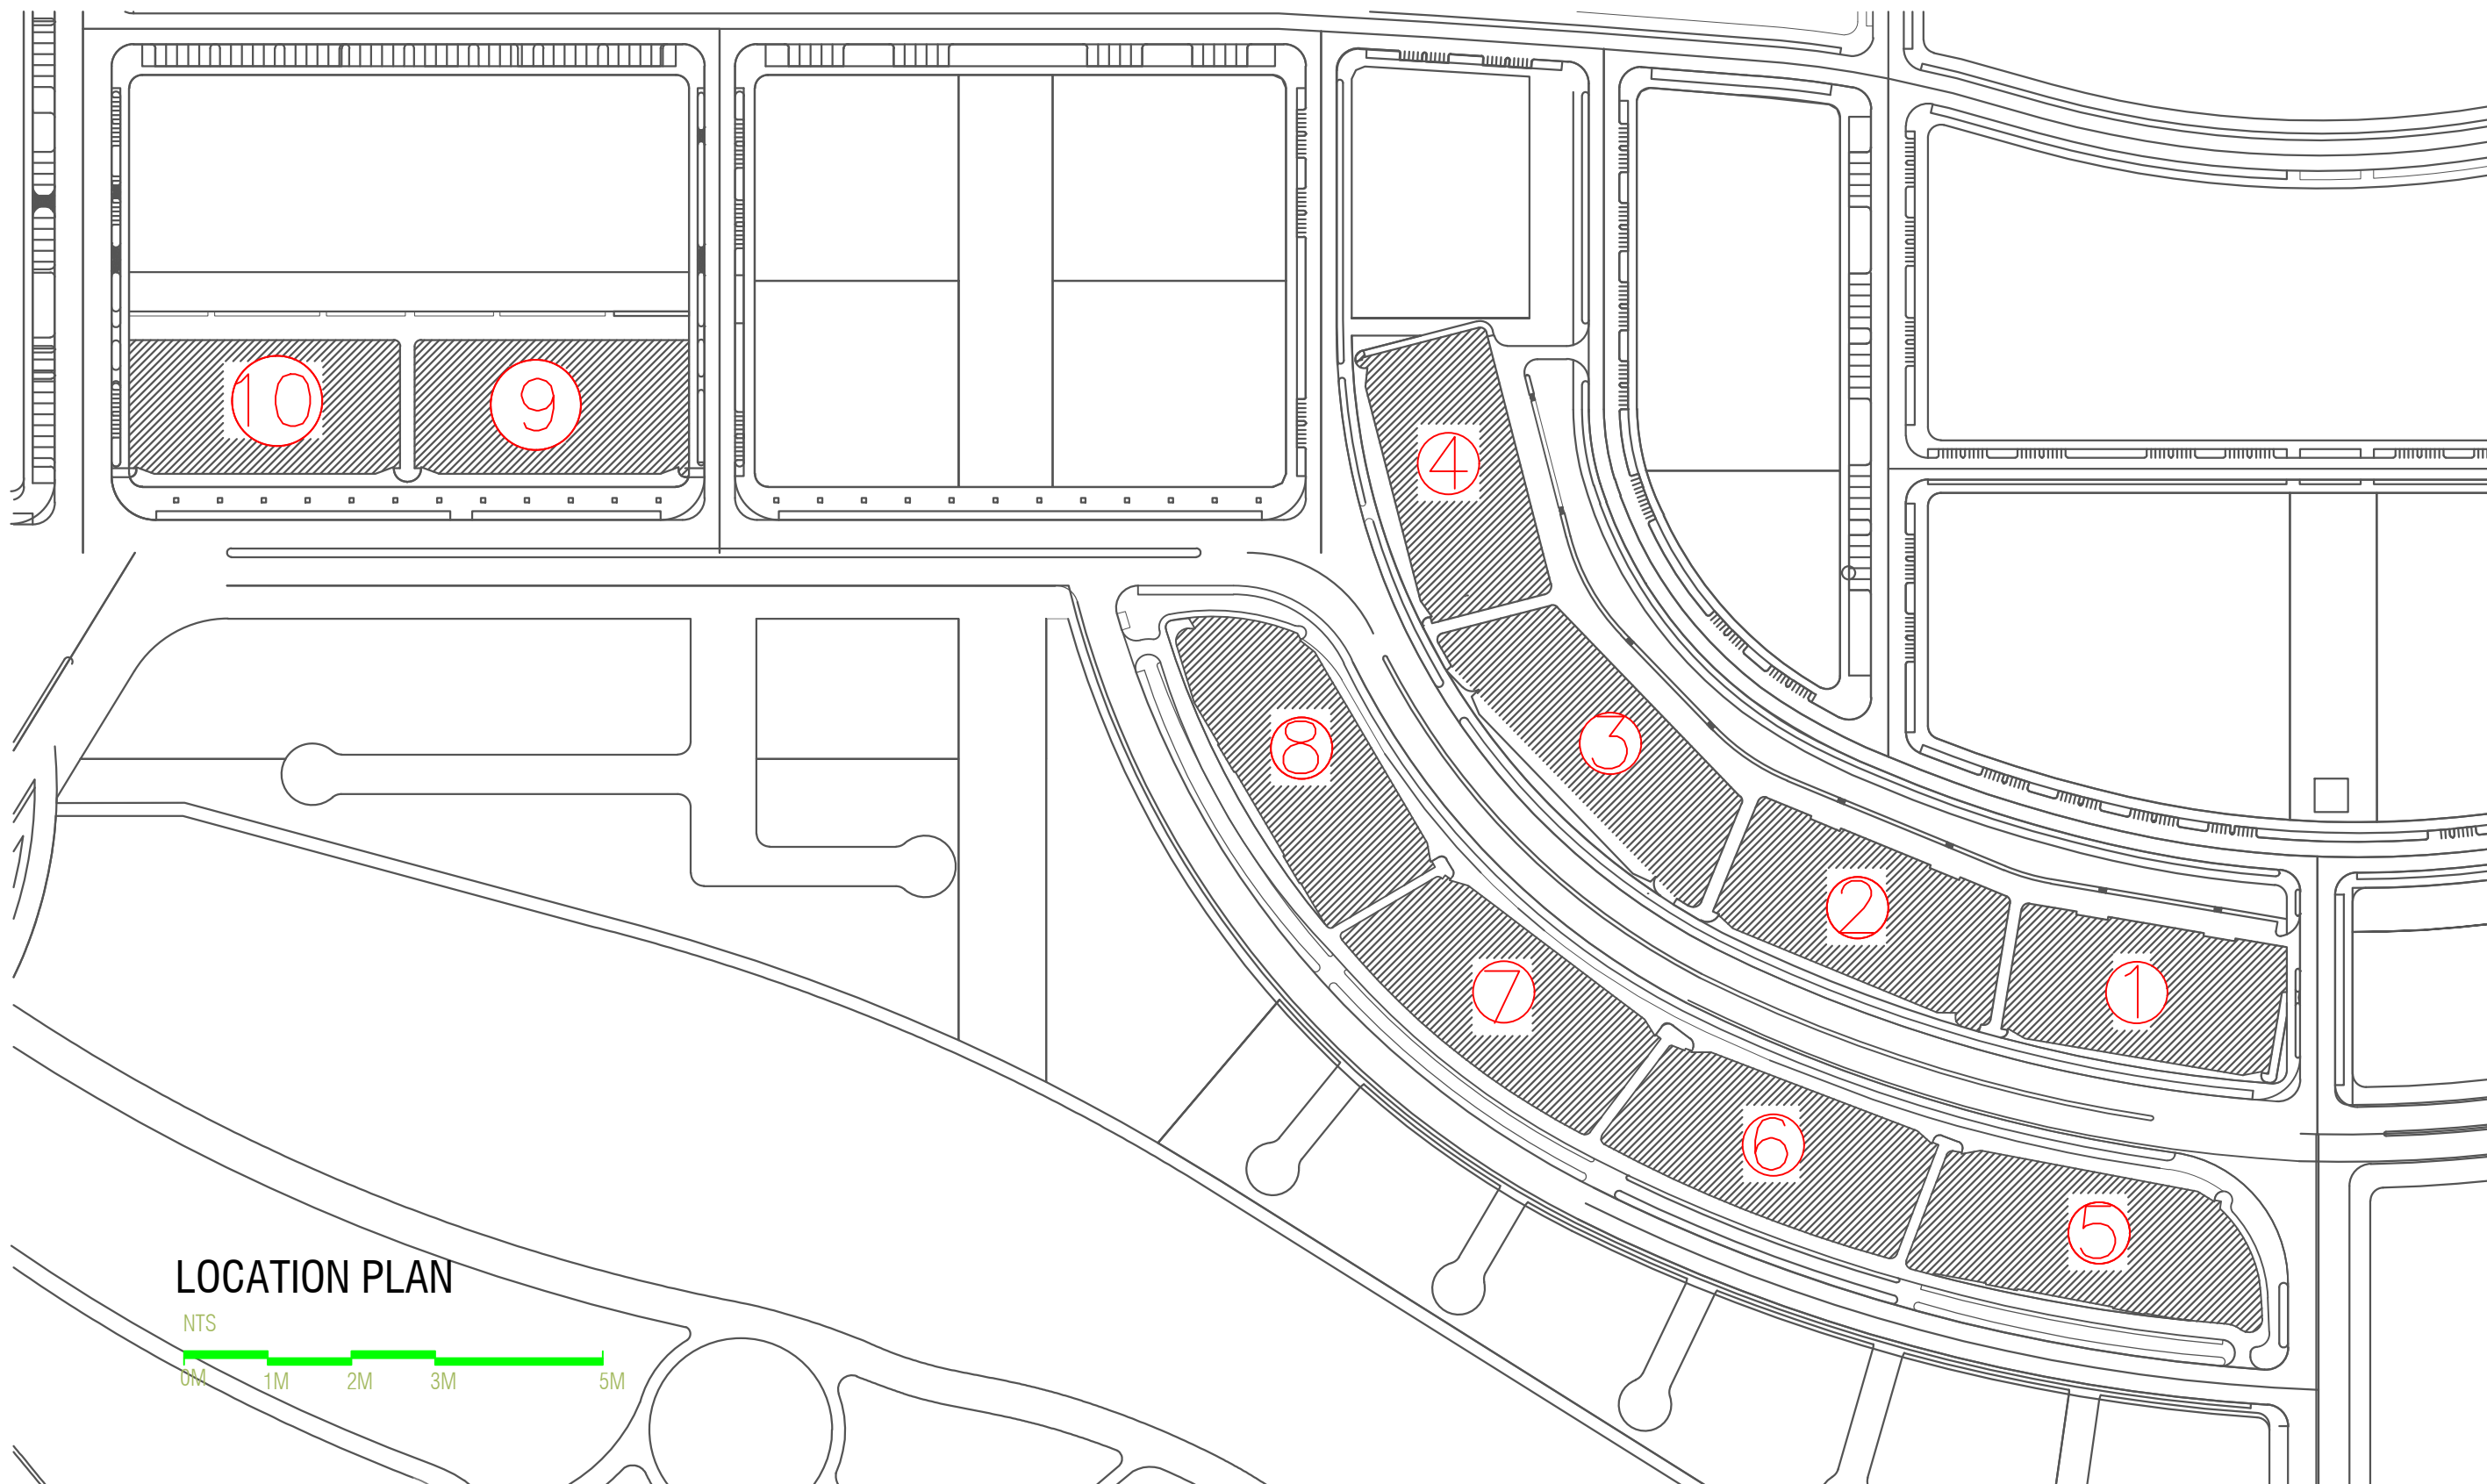

 LOCATION PLAN



PLANNING AND DEVELOPMENT DEPARTMENT
 THIRD FLOOR, HDC BUILDING HULHUMALE'
 REPUBLIC OF MALDIVES
 TEL. +(960)3353535, FAX +(960)3358892
 EMAIL : planning@hdc.com.mv

**VINARES COMMERCIAL
 SEWER PROVISION
 HULHUMALE'**

The drawings, concept and design contained are the properties of HDC. Use of any kind or copy of whole or part of this drawing, concept or design or use on other projects or sites other than that specified on this drawing is strictly prohibited.


DOCUMENT ID	XXXX-SSSS-YYYY-(NUMBER)	VERSION	1
DOCUMENT NAME	VINARES GARBAGE ROOM DRAINAGE	REVISION	-
AUTHOR	MOHAMED NAIL	CREATED DATE	21/01/2024
LAST UPDATED BY	MOHAMED NAIL	LAST UPDATED DATE	03/04/2024
REVIEWED BY	GEORGE	REVIEWED DATE	03/04/2024
APPROVED BY	MOHAMED YAMIN	APPROVED DATE	16/07/2023
INFORMATION CLASSIFICATION SCHEME	[Public, Open, Confidential, Confidential & Sensitive and Secret]		

REVISION HISTORY			
VER.	DATE	REV.	REVISION
X	DD/MM/YYYY	Z	(DRAFT)
X	DD/MM/YYYY	Z	(FEEDBACK FORMS INCLUDED)
X	DD/MM/YYYY	Z	(MODIFIED FEEDBACK FORMS)
X	DD/MM/YYYY	Z	(REFORMATTED FEEDBACK FORM)

ARCHITECT	NAIL
STRUCTURAL ENG.	YAMIN
MECHANICAL ENG.	GEORGE
ELECTRICAL ENG.	NAME
SCALE	AS GIVEN

SHEET CONTENT

SHEET NO.
A01

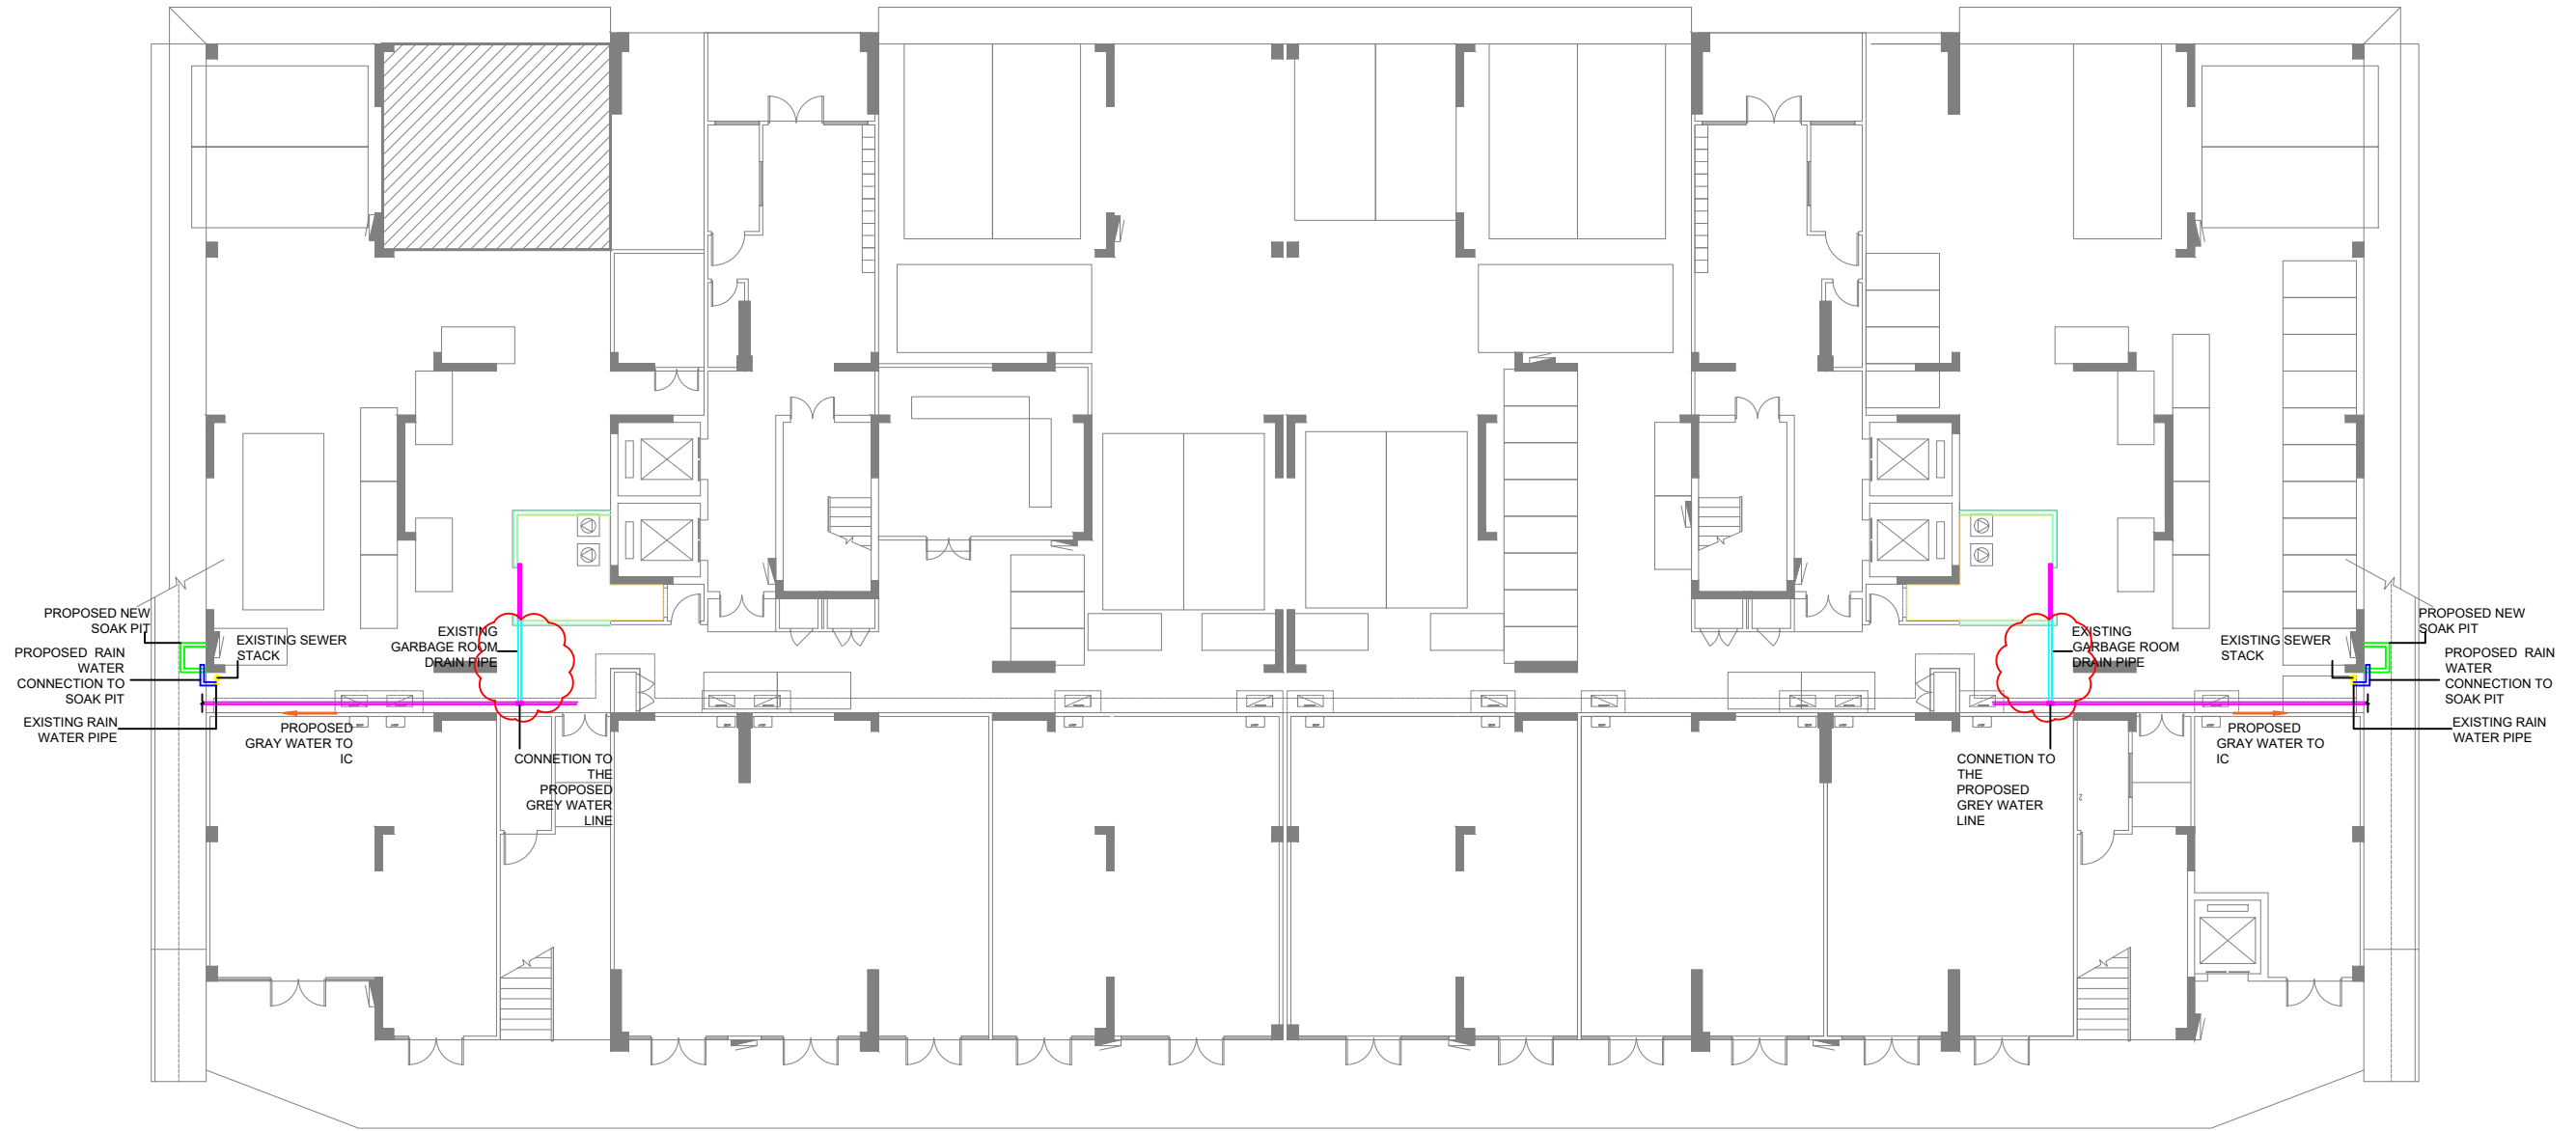

PROPOSED GROUND FLOOR PLAN - BUILDING V1

SCALE 1:200



LEGEND:

- PROPOSED GRAY WATER PIPE
- (C) REDUCER TEE 65mm * 50mm (TAPPING POINT)
- PROPOSED RAINWATER PIPE CONNECTION TO NEW SOAKPIT
- EXISTING DRAIN PIPE FROM GARBAGE ROOM
- PROPOSED NEW SOAK PIT

NOTE:
 - All proposed pipes are UPVC
 - Re-purpose the existing soak pits



**VINARES COMMERCIAL
SEWER PROVISION
HULHUMALE'**

PLANNING AND DEVELOPMENT DEPARTMENT
 THIRD FLOOR, HDC BUILDING HULHUMALE'
 REPUBLIC OF MALDIVES
 TEL. +(960)3353535, FAX +(960)3358892
 EMAIL : planning@hdc.com.mv

The drawings, concept and design contained are the properties of HDC. Use of any kind or copy of whole or part of this drawing, concept or design or use on other projects or sites other than that specified on this drawing is strictly prohibited.

DOCUMENT ID	XXXX-SSSS-YYYY-(NUMBER)	VERSION	1
DOCUMENT NAME	VINARES GARBAGE ROOM DRAINAGE	REVISION	-
AUTHOR	MOHAMED NAIL	CREATED DATE	21/01/2024
LAST UPDATED BY	MOHAMED NAIL	LAST UPDATED DATE	03/04/2024
REVIEWED BY	GEORGE	REVIEWED DATE	03/04/2024
APPROVED BY	MOHAMED YAMIN	APPROVED DATE	16/07/2023
INFORMATION CLASSIFICATION SCHEME	(Public, Open, Confidential, Confidential & Sensitive and Secret)		


REVISION HISTORY			
VER.	DATE	REV.	REVISION
X	DD/MM/YYYY	Z	(DRAFT)
X	DD/MM/YYYY	Z	(FEEDBACK FORMS INCLUDED)
X	DD/MM/YYYY	Z	(MODIFIED FEEDBACK FORMS)
X	DD/MM/YYYY	Z	(REFORMATTED FEEDBACK FORM)

ARCHITECT	NAIL
STRUCTURAL ENG.	YAMIN
MECHANICAL ENG.	GEORGE
ELECTRICAL ENG.	NAME
SCALE	AS GIVEN

SHEET CONTENT	----

SHEET NO.

A02

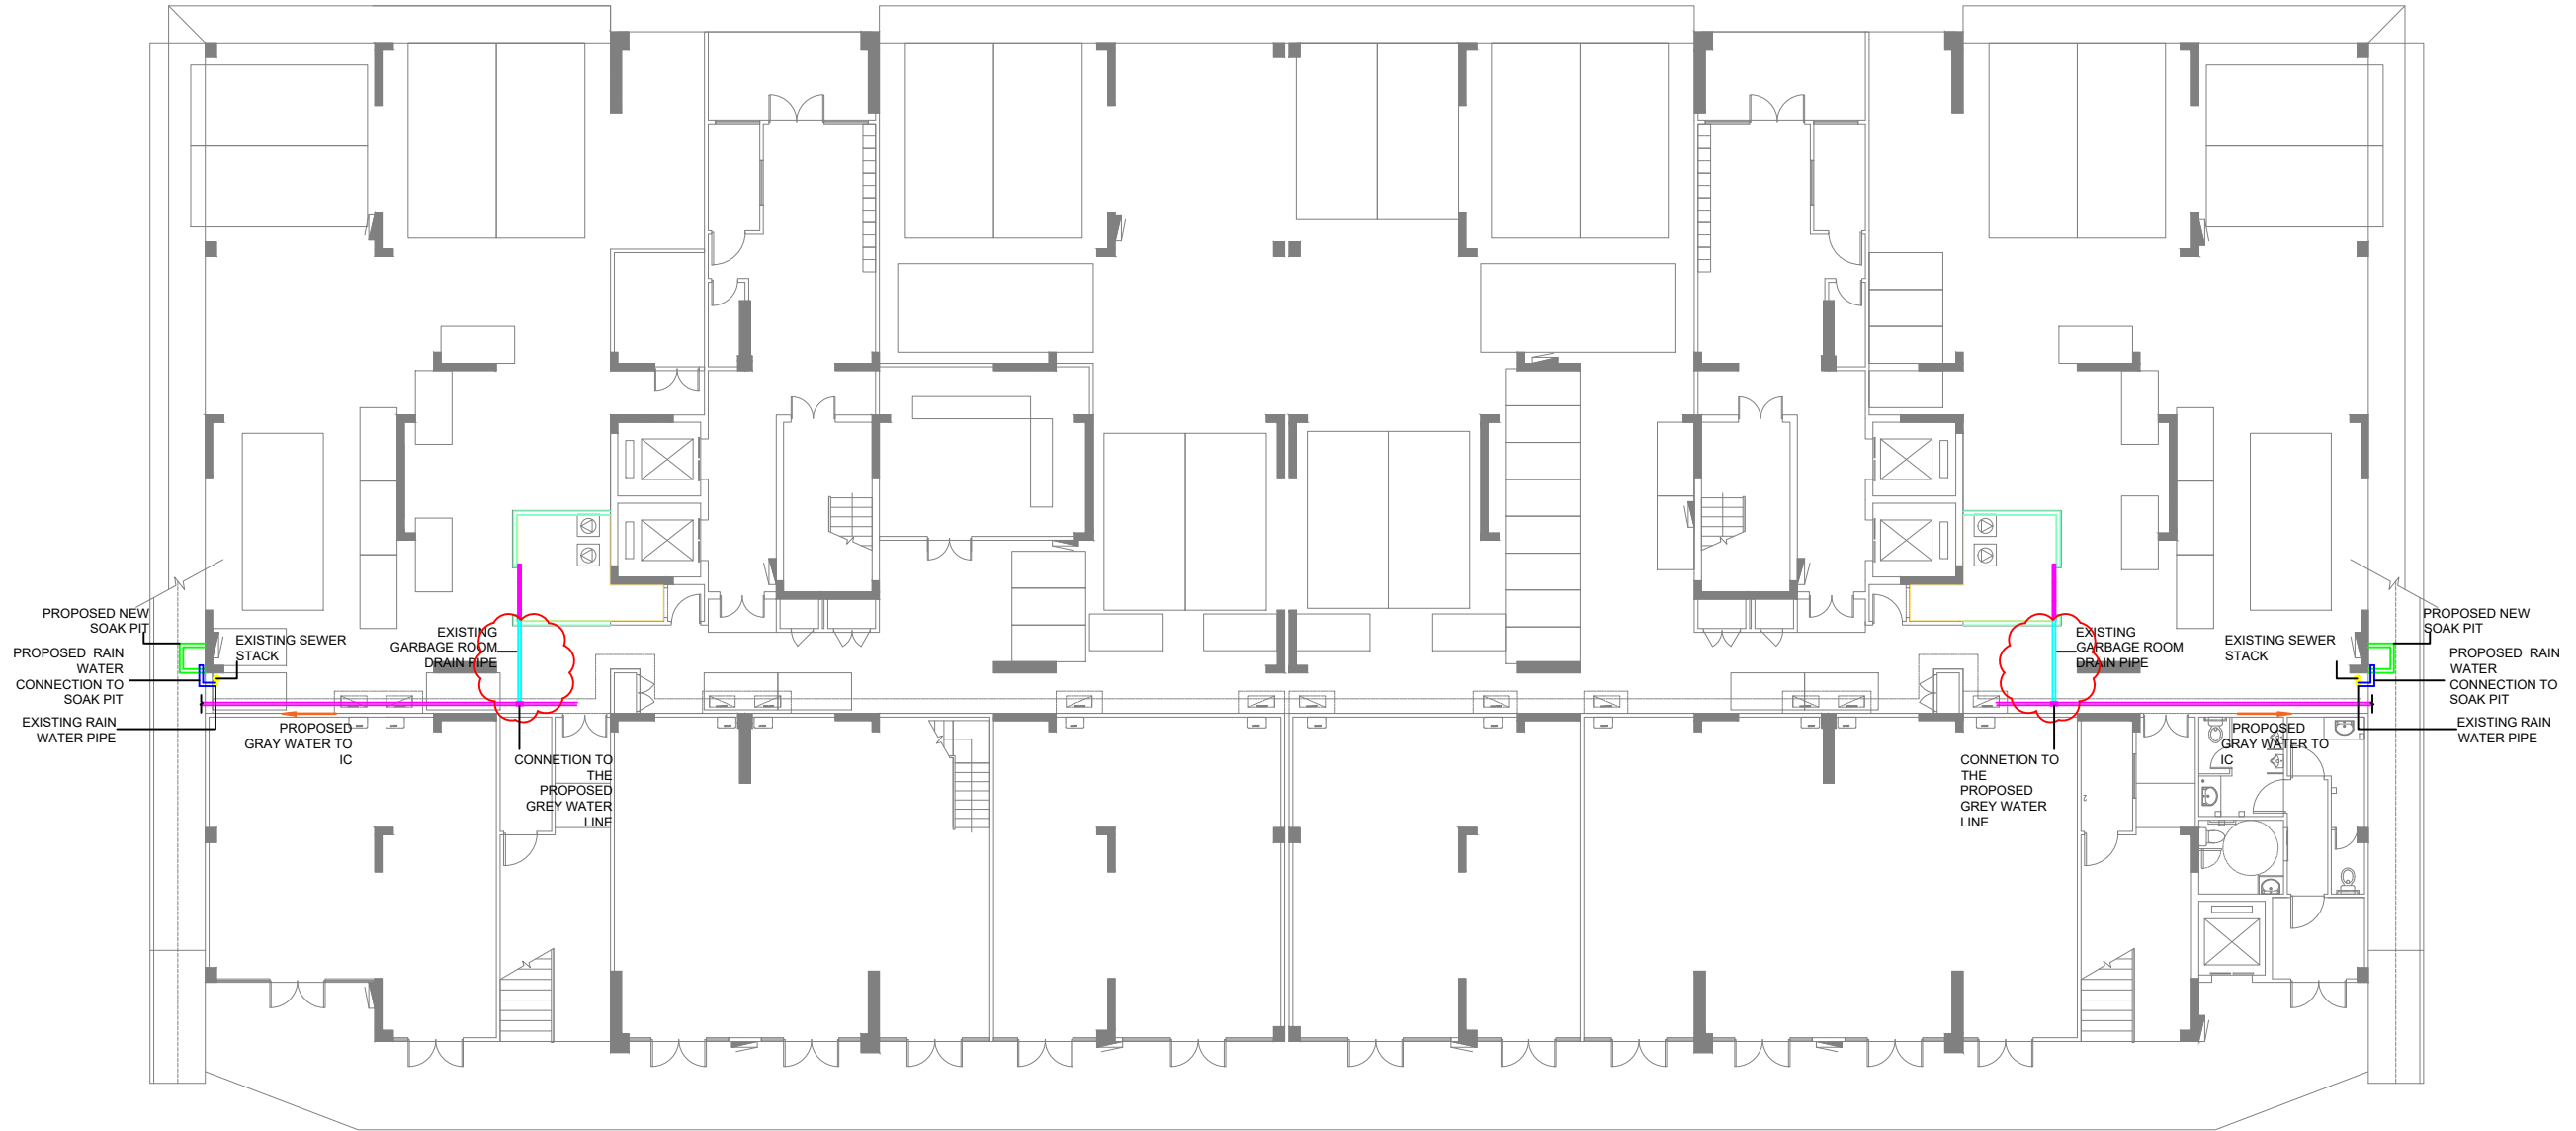

PROPOSED GROUND FLOOR PLAN - BUILDING V2

SCALE 1:200



LEGEND:

	PROPOSED GRAY WATER PIPE
	REDUCER TEE 65mm * 50mm (TAPPING POINT)
	PROPOSED RAINWATER PIPE CONNECTION TO NEW SOAKPIT
	EXISTING DRAIN PIPE FROM GARBAGE ROOM
	PROPOSED NEW SOAK PIT

NOTE:
 - All proposed pipes are UPVC
 - Re-purpose the existing soak pits



**VINARES COMMERCIAL
SEWER PROVISION
HULHUMALE'**

PLANNING AND DEVELOPMENT DEPARTMENT
 THIRD FLOOR, HDC BUILDING HULHUMALE'
 REPUBLIC OF MALDIVES
 TEL. +(960)3353535, FAX +(960)3358892
 EMAIL : planning@hdc.com.mv

The drawings, concept and design contained are the properties of HDC. Use of any kind or copy of whole or part of this drawing, concept or design or use on other projects or sites other than that specified on this drawing is strictly prohibited.

DOCUMENT ID	XXXX-SSSS-YYYY-(NUMBER)	VERSION	1
DOCUMENT NAME	VINARES GARBAGE ROOM DRAINAGE	REVISION	-
AUTHOR	MOHAMED NAIL	CREATED DATE	21/01/2024
LAST UPDATED BY	MOHAMED NAIL	LAST UPDATED DATE	03/04/2024
REVIEWED BY	GEORGE	REVIEWED DATE	03/04/2024
APPROVED BY	MOHAMED YAMIN	APPROVED DATE	16/07/2023
INFORMATION CLASSIFICATION SCHEME	(Public, Open, Confidential, Confidential & Sensitive and Secret)		


REVISION HISTORY			
VER.	DATE	REV.	REVISION
X	DD/MM/YYYY	Z	(DRAFT)
X	DD/MM/YYYY	Z	(FEEDBACK FORMS INCLUDED)
X	DD/MM/YYYY	Z	(MODIFIED FEEDBACK FORMS)
X	DD/MM/YYYY	Z	(REFORMATTED FEEDBACK FORM)

ARCHITECT	NAIL
STRUCTURAL ENG.	YAMIN
MECHANICAL ENG.	GEORGE
ELECTRICAL ENG.	NAME
SCALE	AS GIVEN

SHEET CONTENT	----

SHEET NO.

A03

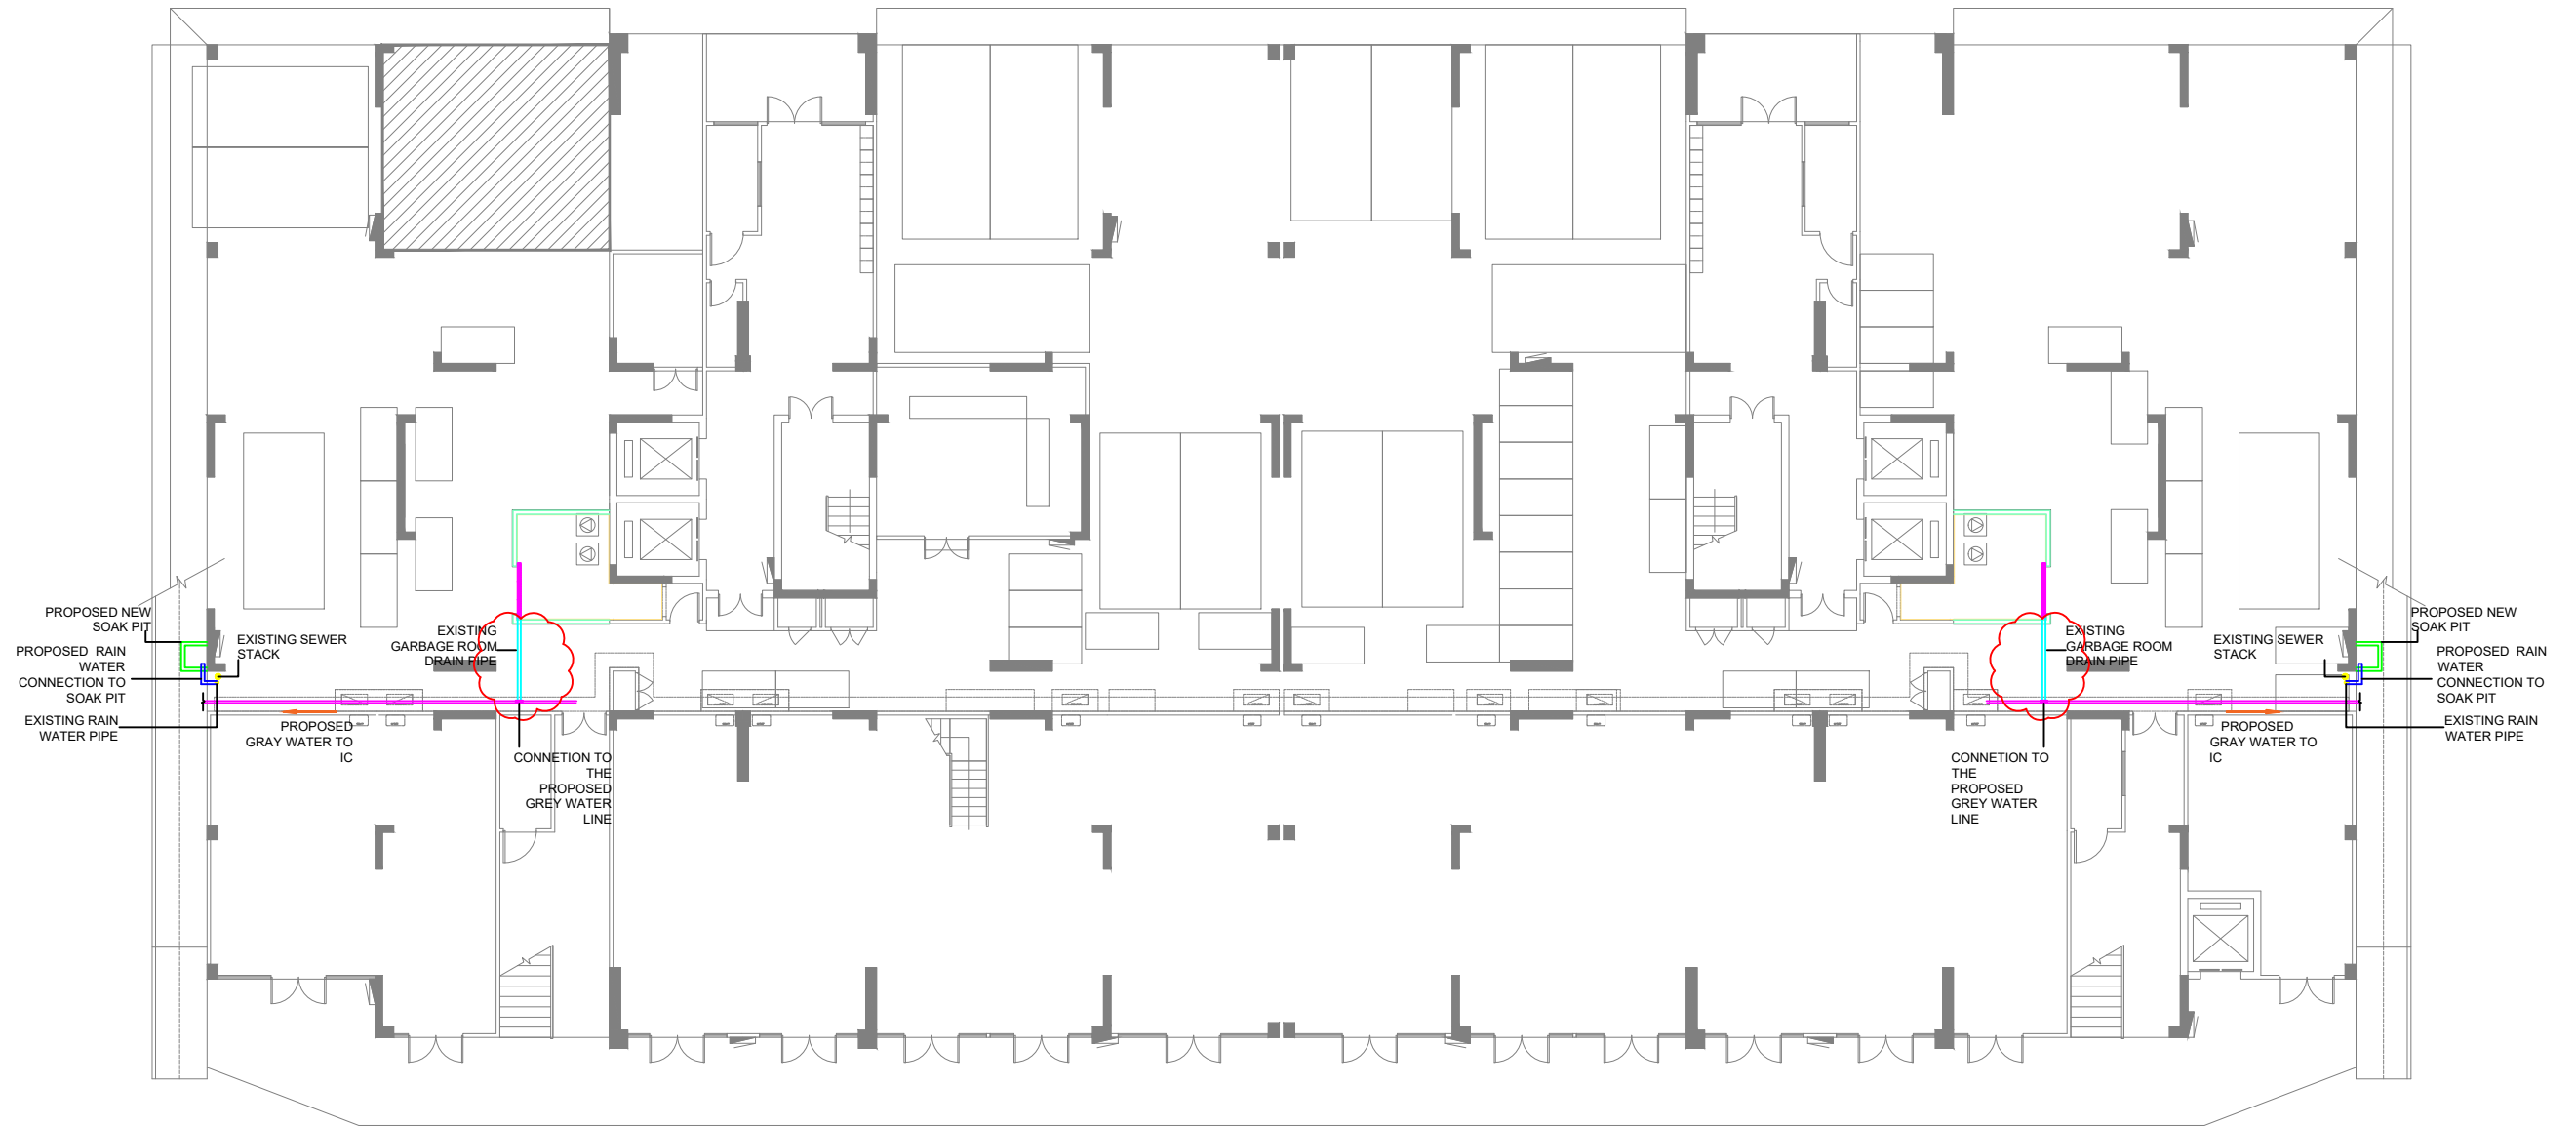

LEGEND:

- PROPOSED GRAY WATER PIPE
- [T] REDUCER TEE 65mm * 50mm (TAPPING POINT)
- PROPOSED RAINWATER PIPE CONNECTION TO NEW SOAKPIT
- EXISTING DRAIN PIPE FROM GARBAGE ROOM
- PROPOSED NEW SOAK PIT

NOTE:

- All proposed pipes are UPVC
- Re-purpose the existing soak pits

PROPOSED GROUND FLOOR PLAN - BUILDING V3

SCALE 1:200



PLANNING AND DEVELOPMENT DEPARTMENT
THIRD FLOOR, HDC BUILDING HULHUMALE'
REPUBLIC OF MALDIVES
TEL. +(960)3353535, FAX +(960)3358892
EMAIL : planning@hdc.com.mv

**VINARES COMMERCIAL
SEWER PROVISION
HULHUMALE'**

The drawings, concept and design contained are the properties of HDC. Use of any kind or copy of whole or part of this drawing, concept or design or use on other projects or sites other than that specified on this drawing is strictly prohibited.

DOCUMENT ID	XXXX-SSSS-YYYY-(NUMBER)	VERSION	1
DOCUMENT NAME	VINARES GARBAGE ROOM DRAINAGE	REVISION	-
AUTHOR	MOHAMED NAIL	CREATED DATE	21/01/2024
LAST UPDATED BY	MOHAMED NAIL	LAST UPDATED DATE	03/04/2024
REVIEWED BY	GEORGE	REVIEWED DATE	03/04/2024
APPROVED BY	MOHAMED YAMIN	APPROVED DATE	16/07/2023
INFORMATION CLASSIFICATION SCHEME	(Public, Open, Confidential, Confidential & Sensitive and Secret)		


REVISION HISTORY			
VER.	DATE	REV.	REVISION
X	DD/MM/YYYY	Z	(DRAFT)
X	DD/MM/YYYY	Z	(FEEDBACK FORMS INCLUDED)
X	DD/MM/YYYY	Z	(MODIFIED FEEDBACK FORMS)
X	DD/MM/YYYY	Z	(REFORMATTED FEEDBACK FORM)

ARCHITECT	NAIL
STRUCTURAL ENG.	YAMIN
MECHANICAL ENG.	GEORGE
ELECTRICAL ENG.	NAME
SCALE	AS GIVEN

SHEET CONTENT	----

SHEET NO.

A04

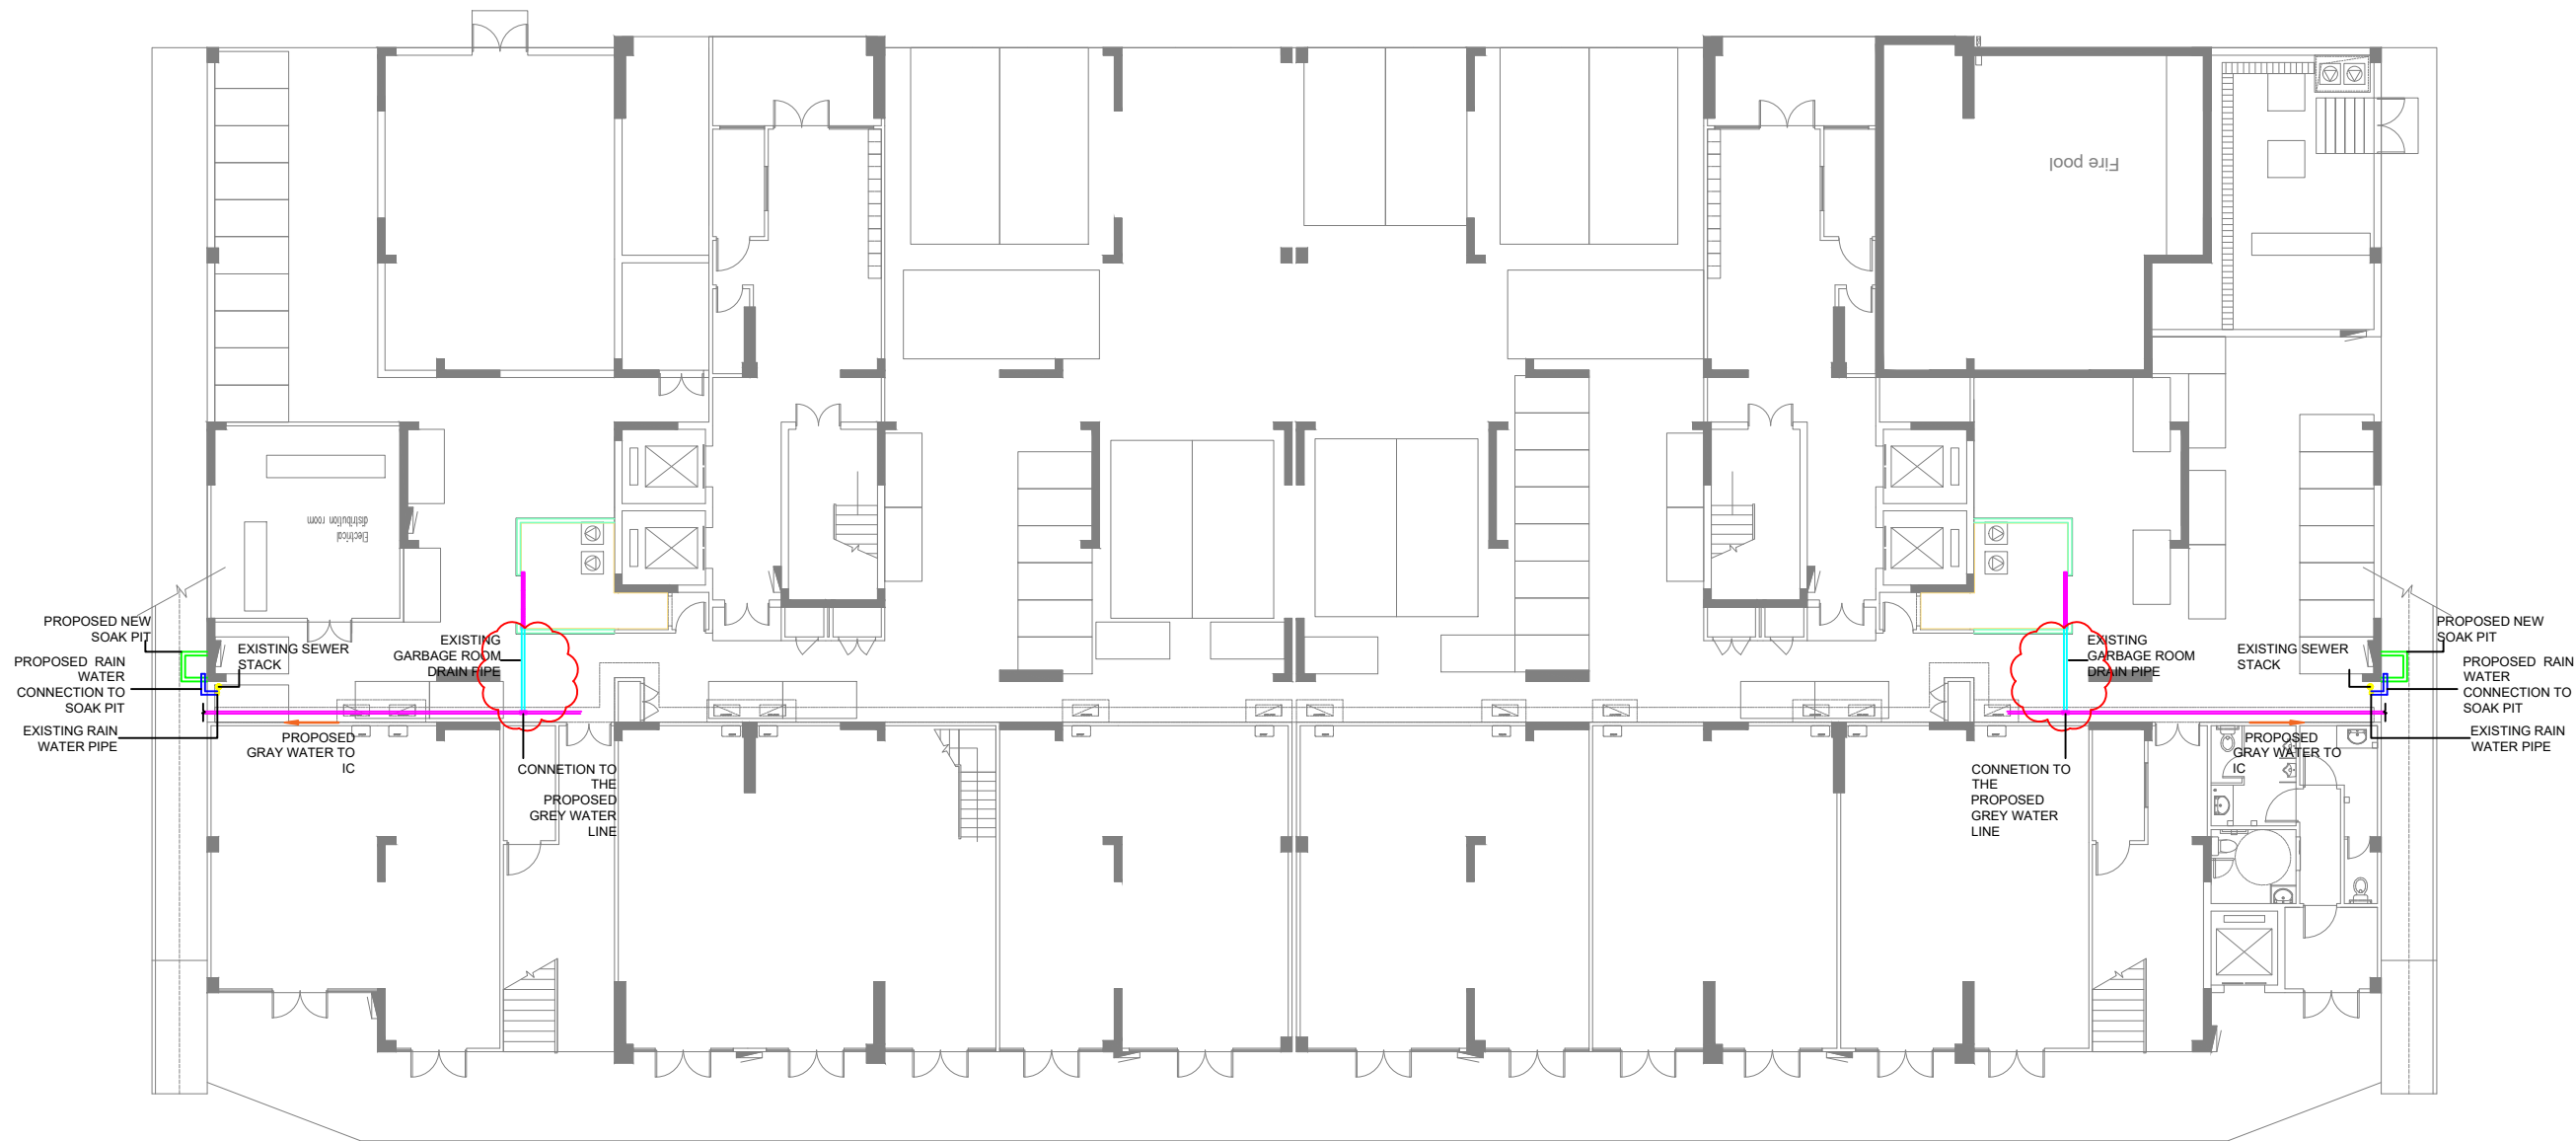

PROPOSED GROUND FLOOR PLAN - BUILDING V4

SCALE 1:200



LEGEND:

- PROPOSED GRAY WATER PIPE
- REDUCER TEE 65mm * 50mm (TAPPING POINT)
- PROPOSED RAINWATER PIPE CONNECTION TO NEW SOAKPIT
- EXISTING DRAIN PIPE FROM GARBAGE ROOM
- PROPOSED NEW SOAK PIT

NOTE:
 - All proposed pipes are UPVC
 - Re-purpose the existing soak pits



**VINARES COMMERCIAL
SEWER PROVISION
HULHUMALE'**

PLANNING AND DEVELOPMENT DEPARTMENT
 THIRD FLOOR, HDC BUILDING HULHUMALE'
 REPUBLIC OF MALDIVES
 TEL. +(960)3353535, FAX +(960)3358892
 EMAIL : planning@hdc.com.mv

The drawings, concept and design contained are the properties of HDC. Use of any kind or copy of whole or part of this drawing, concept or design or use on other projects or sites other than that specified on this drawing is strictly prohibited.

DOCUMENT ID	XXXXX-SSSS-YYYY-(NUMBER)	VERSION	1
DOCUMENT NAME	VINARES GARBAGE ROOM DRAINAGE	REVISION	-
AUTHOR	MOHAMED NAIL	CREATED DATE	21/01/2024
LAST UPDATED BY	MOHAMED NAIL	LAST UPDATED DATE	03/04/2024
REVIEWED BY	GEORGE	REVIEWED DATE	03/04/2024
APPROVED BY	MOHAMED YAMIN	APPROVED DATE	16/07/2023
INFORMATION CLASSIFICATION SCHEME	(Public, Open, Confidential, Confidential & Sensitive and Secret)		

REVISION HISTORY			
VER.	DATE	REV.	REVISION
X	DD/MM/YYYY	Z	(DRAFT)
X	DD/MM/YYYY	Z	(FEEDBACK FORMS INCLUDED)
X	DD/MM/YYYY	Z	(MODIFIED FEEDBACK FORMS)
X	DD/MM/YYYY	Z	(REFORMATTED FEEDBACK FORM)

ARCHITECT	NAIL
STRUCTURAL ENG.	YAMIN
MECHANICAL ENG.	GEORGE
ELECTRICAL ENG.	NAME
SCALE	AS GIVEN

SHEET CONTENT	----

SHEET NO.

A05



PROPOSED GROUND FLOOR PLAN - BUILDING V5

SCALE 1:200



LEGEND:

	PROPOSED GRAY WATER PIPE
	REDUCER TEE 65mm * 50mm (TAPPING POINT)
	PROPOSED RAINWATER PIPE CONNECTION TO NEW SOAKPIT
	EXISTING DRAIN PIPE FROM GARBAGE ROOM
	PROPOSED NEW SOAK PIT

NOTE:
 - All proposed pipes are UPVC
 - Re-purpose the existing soak pits



**VINARES COMMERCIAL
SEWER PROVISION
HULHUMALE'**

PLANNING AND DEVELOPMENT DEPARTMENT
 THIRD FLOOR, HDC BUILDING HULHUMALE'
 REPUBLIC OF MALDIVES
 TEL: +(960)3353535, FAX +(960)3358892
 EMAIL: planning@hdc.com.mv

The drawings, concept and design contained are the properties of HDC. Use of any kind or copy of whole or part of this drawing, concept or design or use on other projects or sites other than that specified on this drawing is strictly prohibited.


DOCUMENT ID	XXXXX-SSSS-YYYY-(NUMBER)	VERSION	1
DOCUMENT NAME	VINARES GARBAGE ROOM DRAINAGE	REVISION	-
AUTHOR	MOHAMED NAIL	CREATED DATE	21/01/2024
LAST UPDATED BY	MOHAMED NAIL	LAST UPDATED DATE	03/04/2024
REVIEWED BY	GEORGE	REVIEWED DATE	03/04/2024
APPROVED BY	MOHAMED YAMIN	APPROVED DATE	16/07/2023
INFORMATION CLASSIFICATION SCHEME	(Public, Open, Confidential, Confidential & Sensitive and Secret)		

REVISION HISTORY			
VER.	DATE	REV.	REVISION
X	DD/MM/YYYY	Z	(DRAFT)
X	DD/MM/YYYY	Z	(FEEDBACK FORMS INCLUDED)
X	DD/MM/YYYY	Z	(MODIFIED FEEDBACK FORMS)
X	DD/MM/YYYY	Z	(REFORMATTED FEEDBACK FORM)

ARCHITECT	NAIL
STRUCTURAL ENG.	YAMIN
MECHANICAL ENG.	GEORGE
ELECTRICAL ENG.	NAME
SCALE	AS GIVEN

SHEET CONTENT	----

SHEET NO.
A06

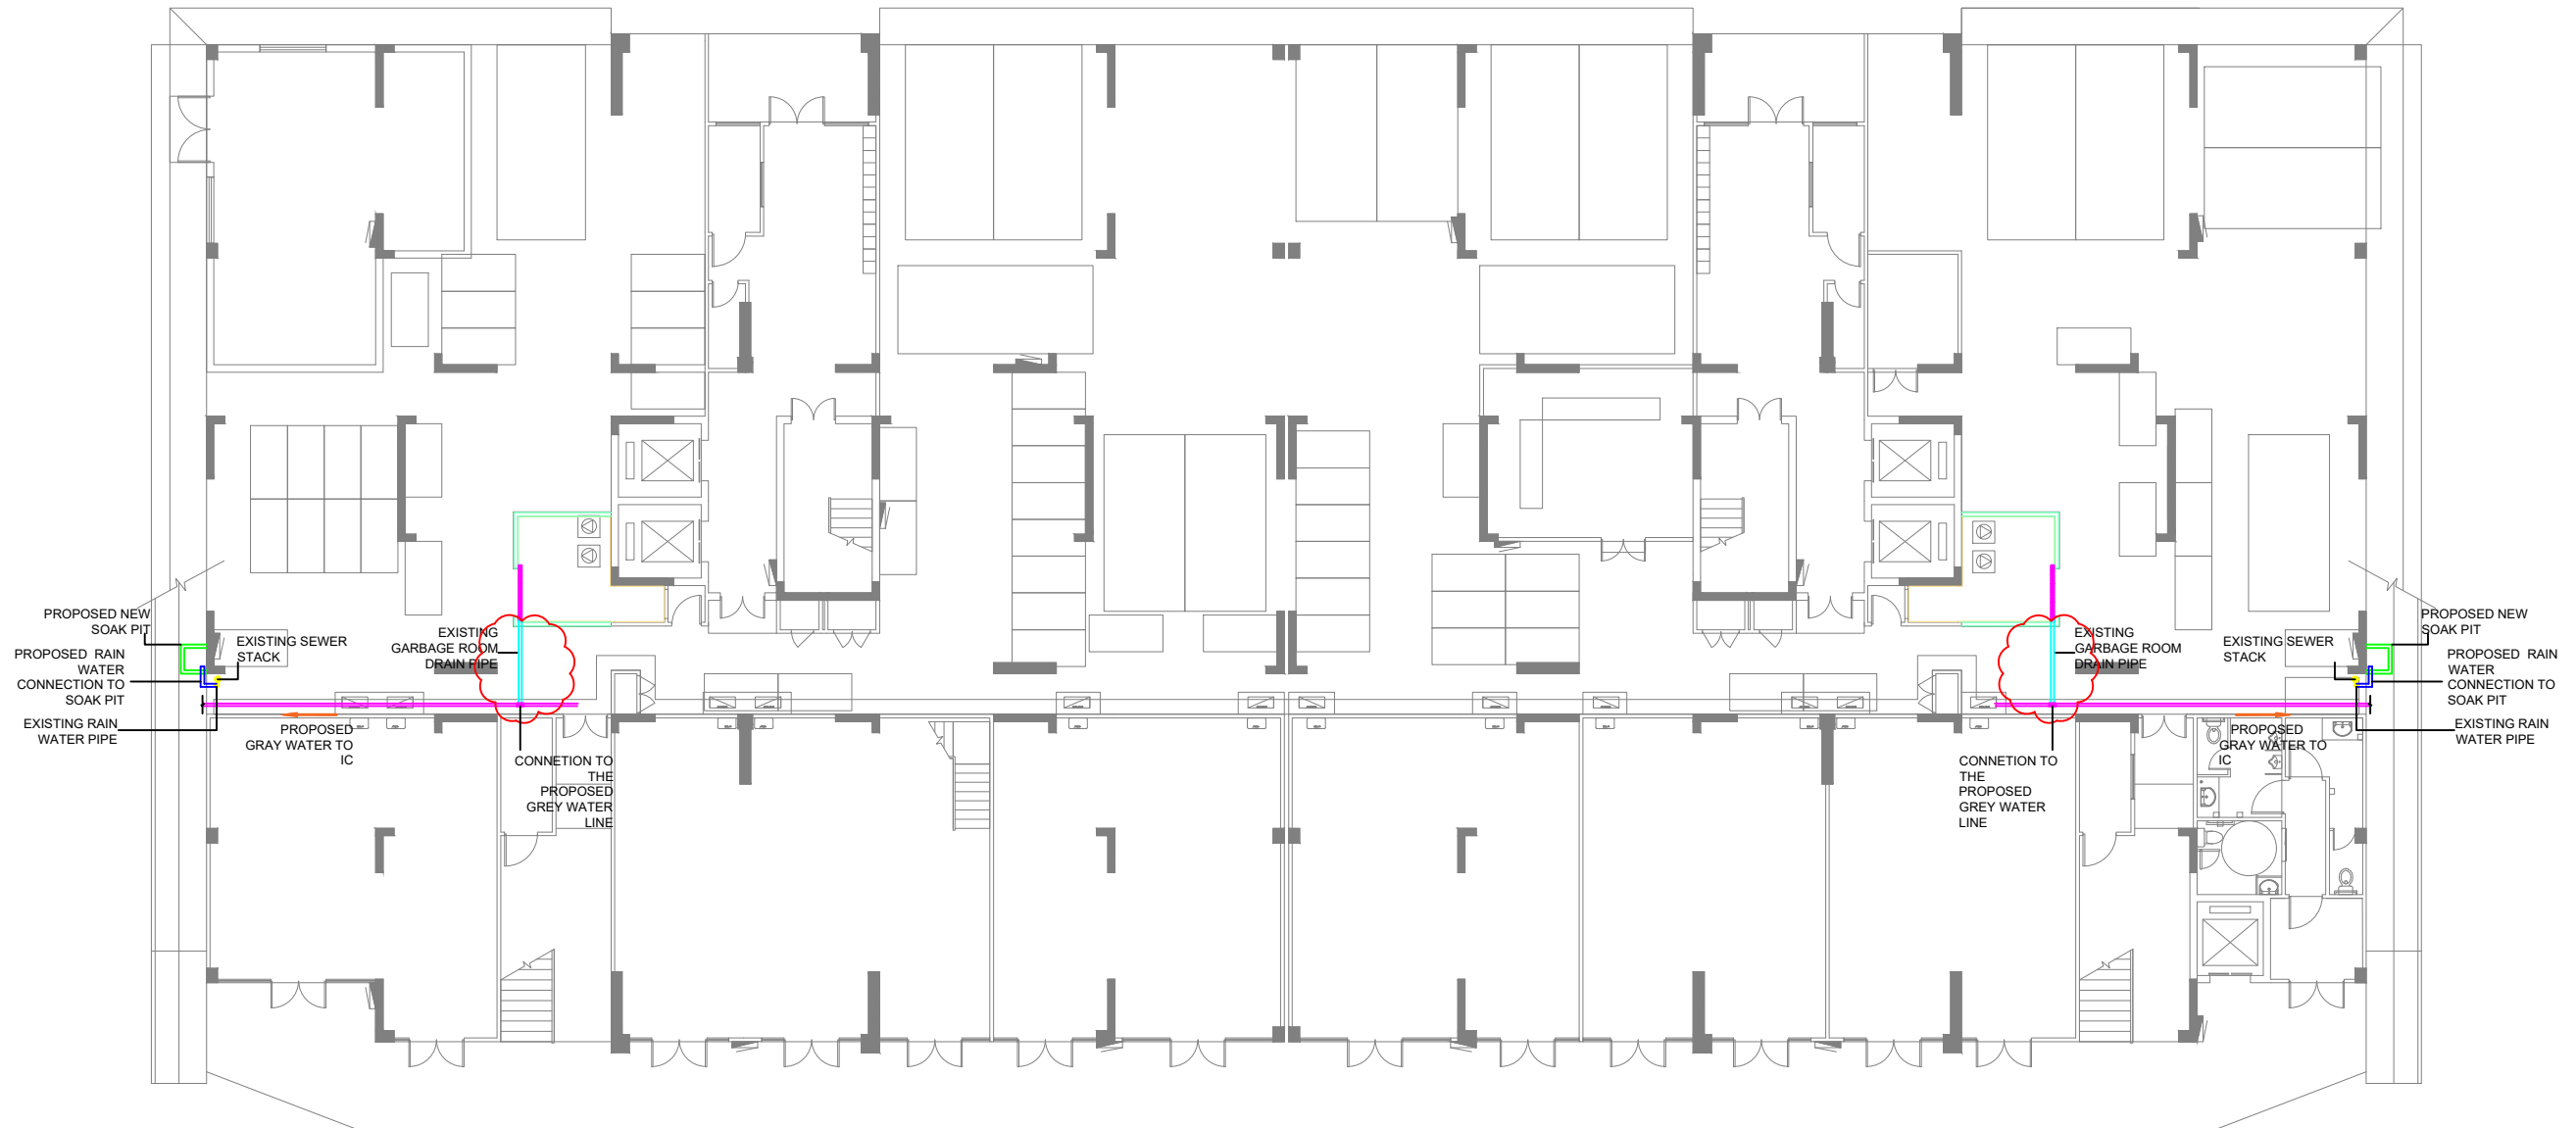

PROPOSED GROUND FLOOR PLAN - BUILDING V6

SCALE 1:200



LEGEND:

	PROPOSED GRAY WATER PIPE
	REDUCER TEE 65mm * 50mm (TAPPING POINT)
	PROPOSED RAINWATER PIPE CONNECTION TO NEW SOAKPIT
	EXISTING DRAIN PIPE FROM GARBAGE ROOM
	PROPOSED NEW SOAK PIT

NOTE:
 - All proposed pipes are UPVC
 - Re-purpose the existing soak pits



**VINARES COMMERCIAL
SEWER PROVISION
HULHUMALE'**

PLANNING AND DEVELOPMENT DEPARTMENT
 THIRD FLOOR, HDC BUILDING HULHUMALE'
 REPUBLIC OF MALDIVES
 TEL. +(960)3353535, FAX +(960)3358892
 EMAIL : planning@hdc.com.mv

The drawings, concept and design contained are the properties of HDC. Use of any kind or copy of whole or part of this drawing, concept or design or use on other projects or sites other than that specified on this drawing is strictly prohibited.


DOCUMENT ID	XXXX-SSSS-YYYY-(NUMBER)	VERSION	1
DOCUMENT NAME	VINARES GARBAGE ROOM DRAINAGE	REVISION	-
AUTHOR	MOHAMED NAIL	CREATED DATE	21/01/2024
LAST UPDATED BY	MOHAMED NAIL	LAST UPDATED DATE	03/04/2024
REVIEWED BY	GEORGE	REVIEWED DATE	03/04/2024
APPROVED BY	MOHAMED YAMIN	APPROVED DATE	16/07/2023
INFORMATION CLASSIFICATION SCHEME	(Public, Open, Confidential, Confidential & Sensitive and Secret)		

REVISION HISTORY			
VER.	DATE	REV.	REVISION
X	DD/MM/YYYY	Z	(DRAFT)
X	DD/MM/YYYY	Z	(FEEDBACK FORMS INCLUDED)
X	DD/MM/YYYY	Z	(MODIFIED FEEDBACK FORMS)
X	DD/MM/YYYY	Z	(REFORMATTED FEEDBACK FORM)

ARCHITECT	NAIL
STRUCTURAL ENG.	YAMIN
MECHANICAL ENG.	GEORGE
ELECTRICAL ENG.	NAME
SCALE	AS GIVEN

SHEET CONTENT	----

SHEET NO.
A07

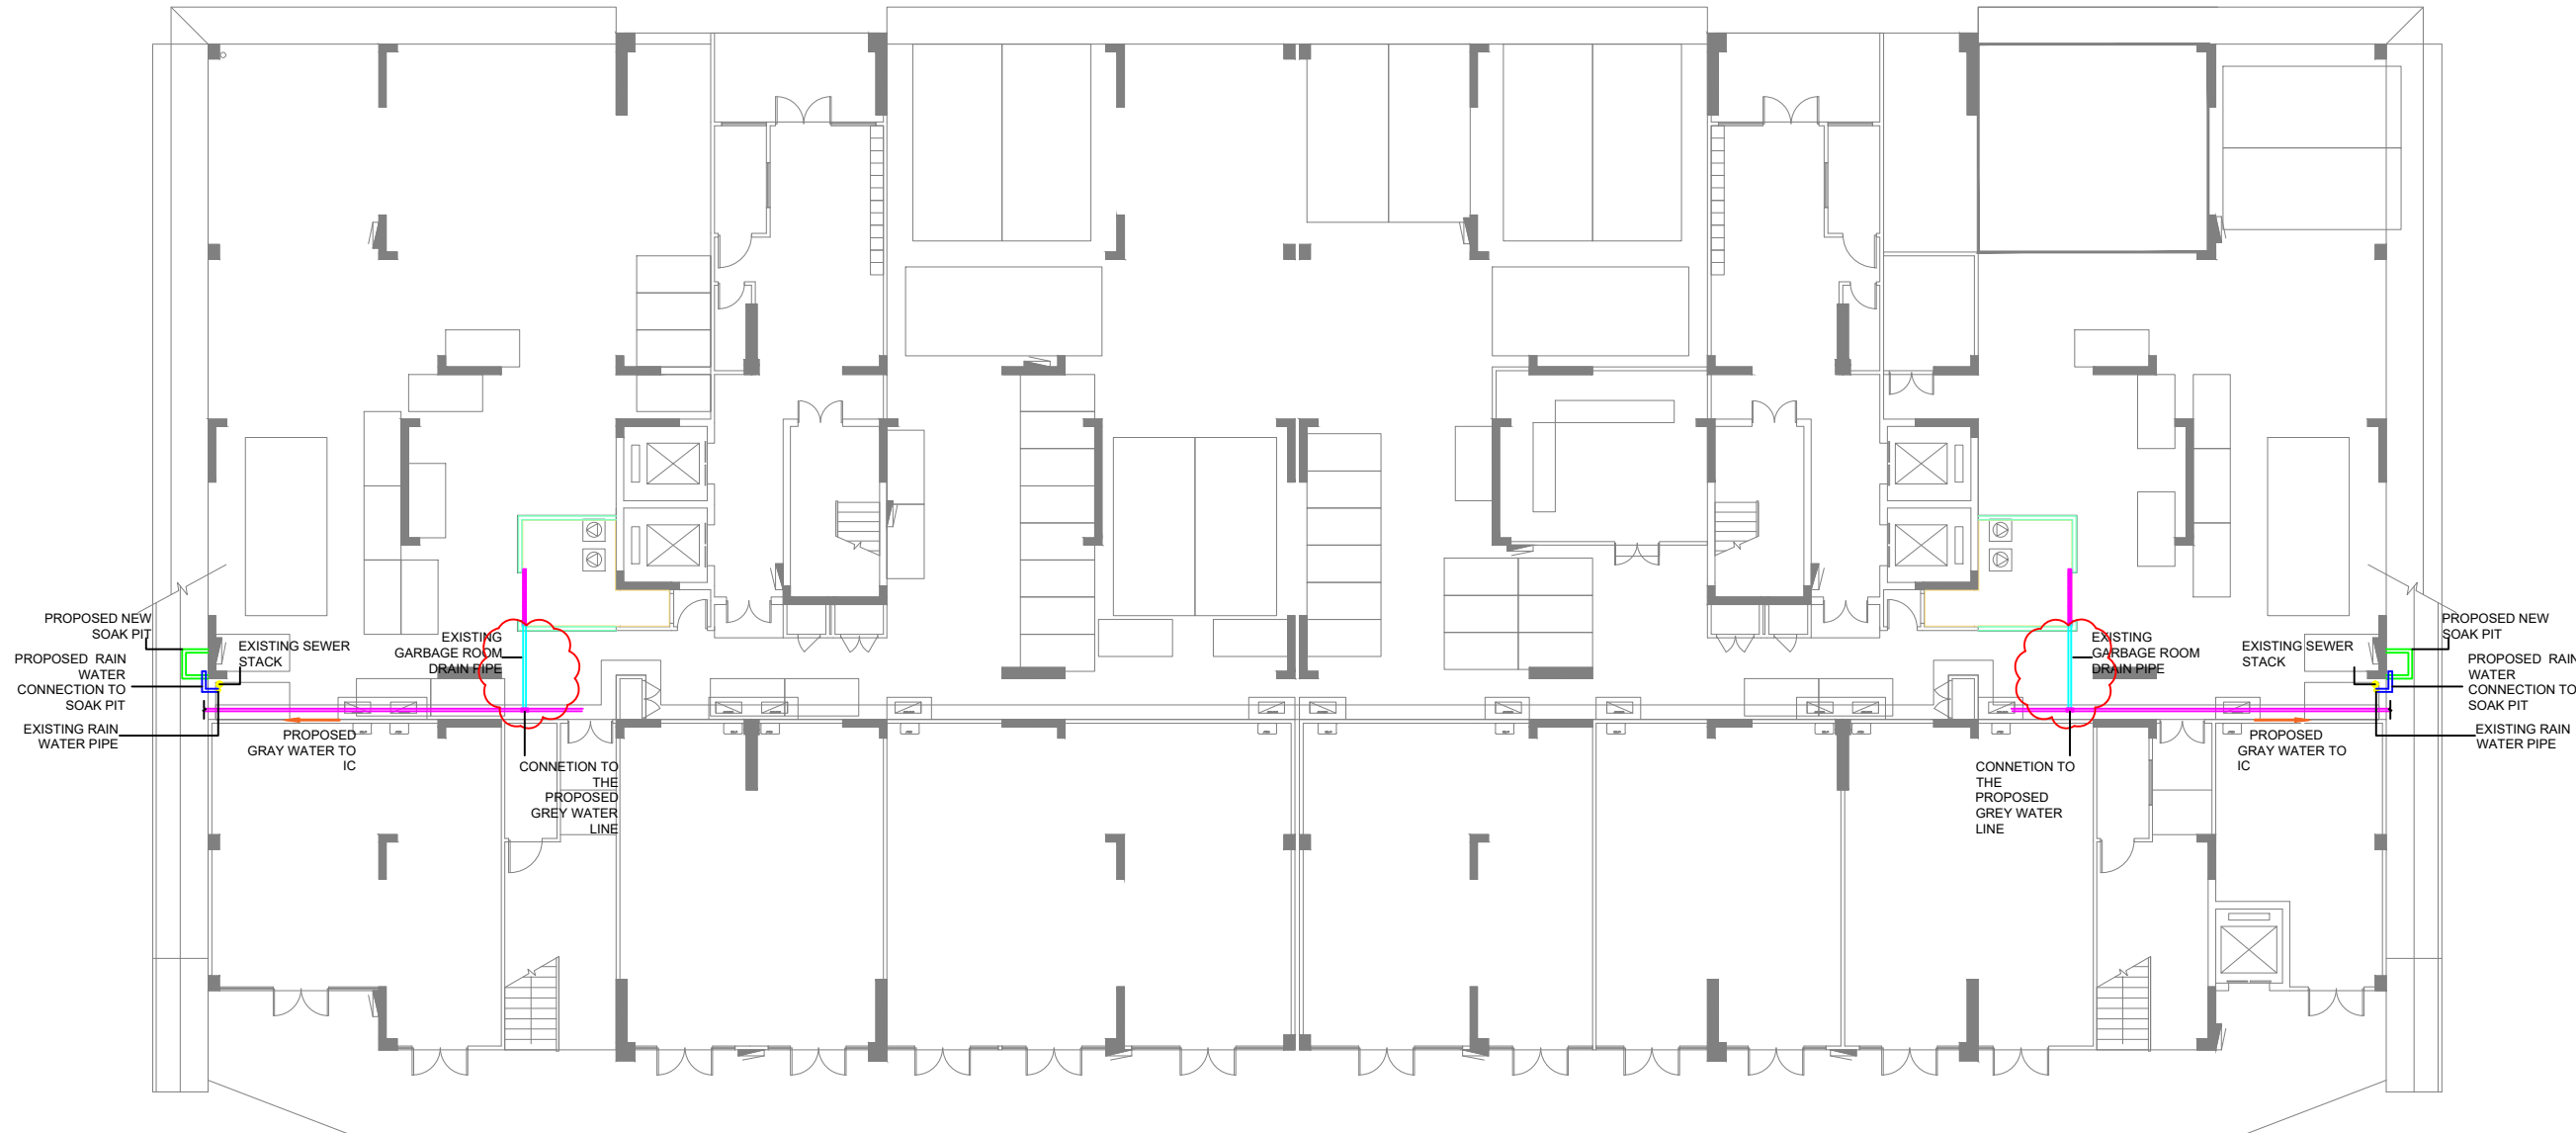

PROPOSED GROUND FLOOR PLAN - BUILDING V7

SCALE 1:200



LEGEND:

	PROPOSED GRAY WATER PIPE
	REDUCER TEE 65mm * 50mm (TAPPING POINT)
	PROPOSED RAINWATER PIPE CONNECTION TO NEW SOAKPIT
	EXISTING DRAIN PIPE FROM GARBAGE ROOM
	PROPOSED NEW SOAK PIT

NOTE:
 - All proposed pipes are UPVC
 - Re-purpose the existing soak pits



**VINARES COMMERCIAL
SEWER PROVISION
HULHUMALE'**

PLANNING AND DEVELOPMENT DEPARTMENT
 THIRD FLOOR, HDC BUILDING HULHUMALE'
 REPUBLIC OF MALDIVES
 TEL. +(960)3353535, FAX +(960)3358892
 EMAIL : planning@hdc.com.mv

The drawings, concept and design contained are the properties of HDC. Use of any kind or copy of whole or part of this drawing, concept or design or use on other projects or sites other than that specified on this drawing is strictly prohibited.

DOCUMENT ID	XXXX-SSSS-YYYY-(NUMBER)	VERSION	1
DOCUMENT NAME	VINARES GARBAGE ROOM DRAINAGE	REVISION	-
AUTHOR	MOHAMED NAIL	CREATED DATE	21/01/2024
LAST UPDATED BY	MOHAMED NAIL	LAST UPDATED DATE	03/04/2024
REVIEWED BY	GEORGE	REVIEWED DATE	03/04/2024
APPROVED BY	MOHAMED YAMIN	APPROVED DATE	16/07/2023
INFORMATION CLASSIFICATION SCHEME	(Public, Open, Confidential, Confidential & Sensitive and Secret)		


REVISION HISTORY			
VER.	DATE	REV.	REVISION
X	DD/MM/YYYY	Z	(DRAFT)
X	DD/MM/YYYY	Z	(FEEDBACK FORMS INCLUDED)
X	DD/MM/YYYY	Z	(MODIFIED FEEDBACK FORMS)
X	DD/MM/YYYY	Z	(REFORMATTED FEEDBACK FORM)

ARCHITECT	NAIL
STRUCTURAL ENG.	YAMIN
MECHANICAL ENG.	GEORGE
ELECTRICAL ENG.	NAME
SCALE	AS GIVEN

SHEET CONTENT	----

SHEET NO.

A08

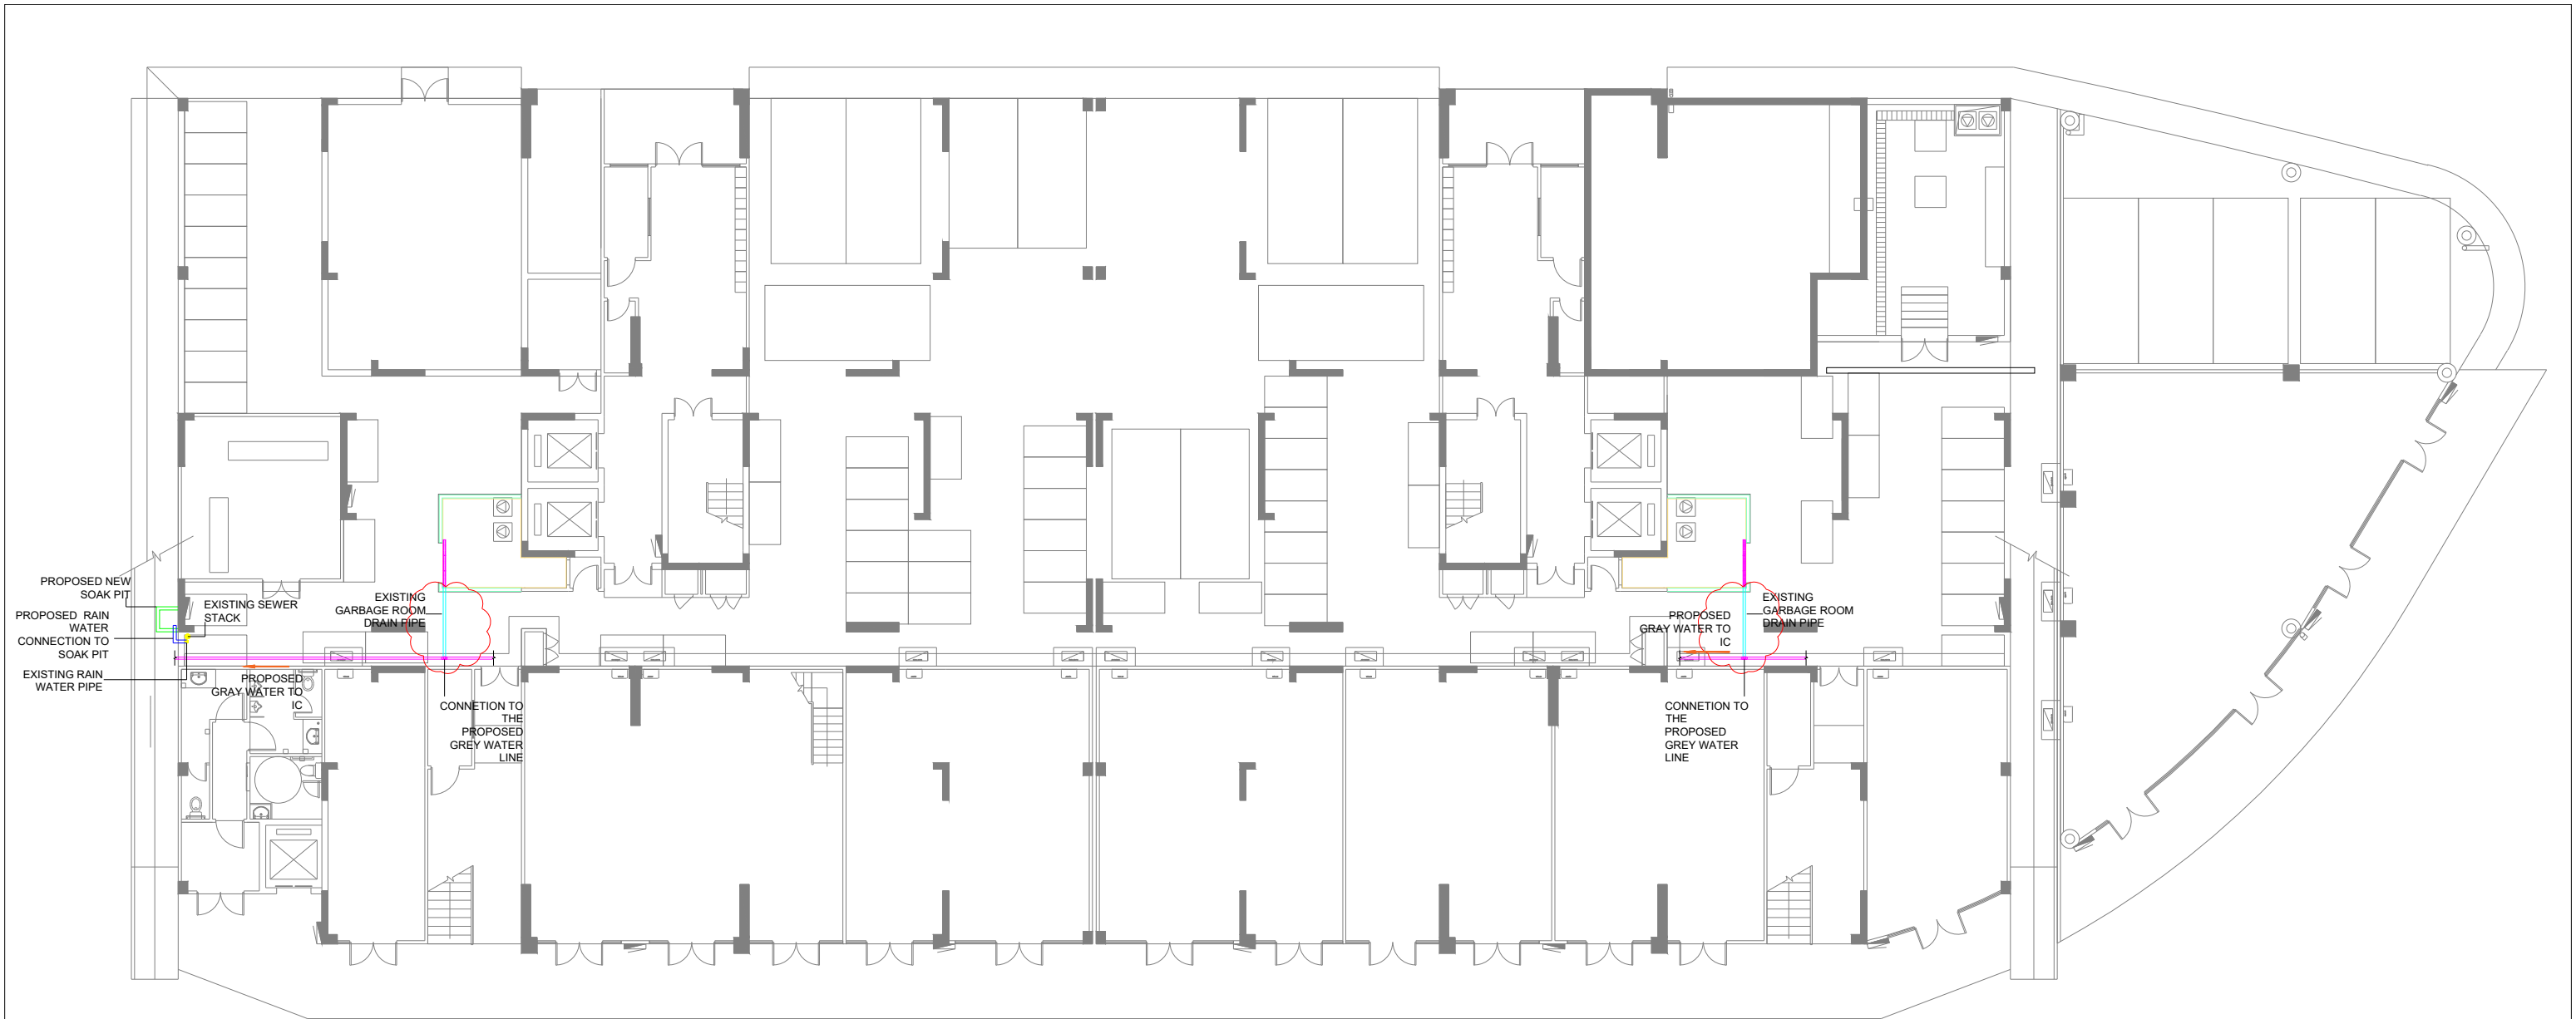

PROPOSED GROUND FLOOR PLAN - BUILDING V8

SCALE 1:200



LEGEND:

	PROPOSED GRAY WATER PIPE
	REDUCER TEE 65mm * 50mm (TAPPING POINT)
	PROPOSED RAINWATER PIPE CONNECTION TO NEW SOAKPIT
	EXISTING DRAIN PIPE FROM GARBAGE ROOM
	PROPOSED NEW SOAK PIT

NOTE:
 - All proposed pipes are UPVC
 - Re-purpose the existing soak pits



**VINARES COMMERCIAL
SEWER PROVISION
HULHUMALE'**

PLANNING AND DEVELOPMENT DEPARTMENT
 THIRD FLOOR, HDC BUILDING HULHUMALE'
 REPUBLIC OF MALDIVES
 TEL. +(960)3353535, FAX +(960)3358892
 EMAIL : planning@hdc.com.mv

The drawings, concept and design contained are the properties of HDC. Use of any kind or copy of whole or part of this drawing, concept or design or use on other projects or sites other than that specified on this drawing is strictly prohibited.

DOCUMENT ID	XXXX-SSSS-YYYY-(NUMBER)	VERSION	1
DOCUMENT NAME	VINARES GARBAGE ROOM DRAINAGE	REVISION	-
AUTHOR	MOHAMED NAIL	CREATED DATE	21/01/2024
LAST UPDATED BY	MOHAMED NAIL	LAST UPDATED DATE	03/04/2024
REVIEWED BY	GEORGE	REVIEWED DATE	03/04/2024
APPROVED BY	MOHAMED YAMIN	APPROVED DATE	16/07/2023
INFORMATION CLASSIFICATION SCHEME	(Public, Open, Confidential, Confidential & Sensitive and Secret)		


REVISION HISTORY			
VER.	DATE	REV.	REVISION
X	DD/MM/YYYY	Z	(DRAFT)
X	DD/MM/YYYY	Z	(FEEDBACK FORMS INCLUDED)
X	DD/MM/YYYY	Z	(MODIFIED FEEDBACK FORMS)
X	DD/MM/YYYY	Z	(REFORMATTED FEEDBACK FORM)

ARCHITECT	NAIL
STRUCTURAL ENG.	YAMIN
MECHANICAL ENG.	GEORGE
ELECTRICAL ENG.	NAME
SCALE	AS GIVEN


SHEET CONTENT	----

SHEET NO.

A09

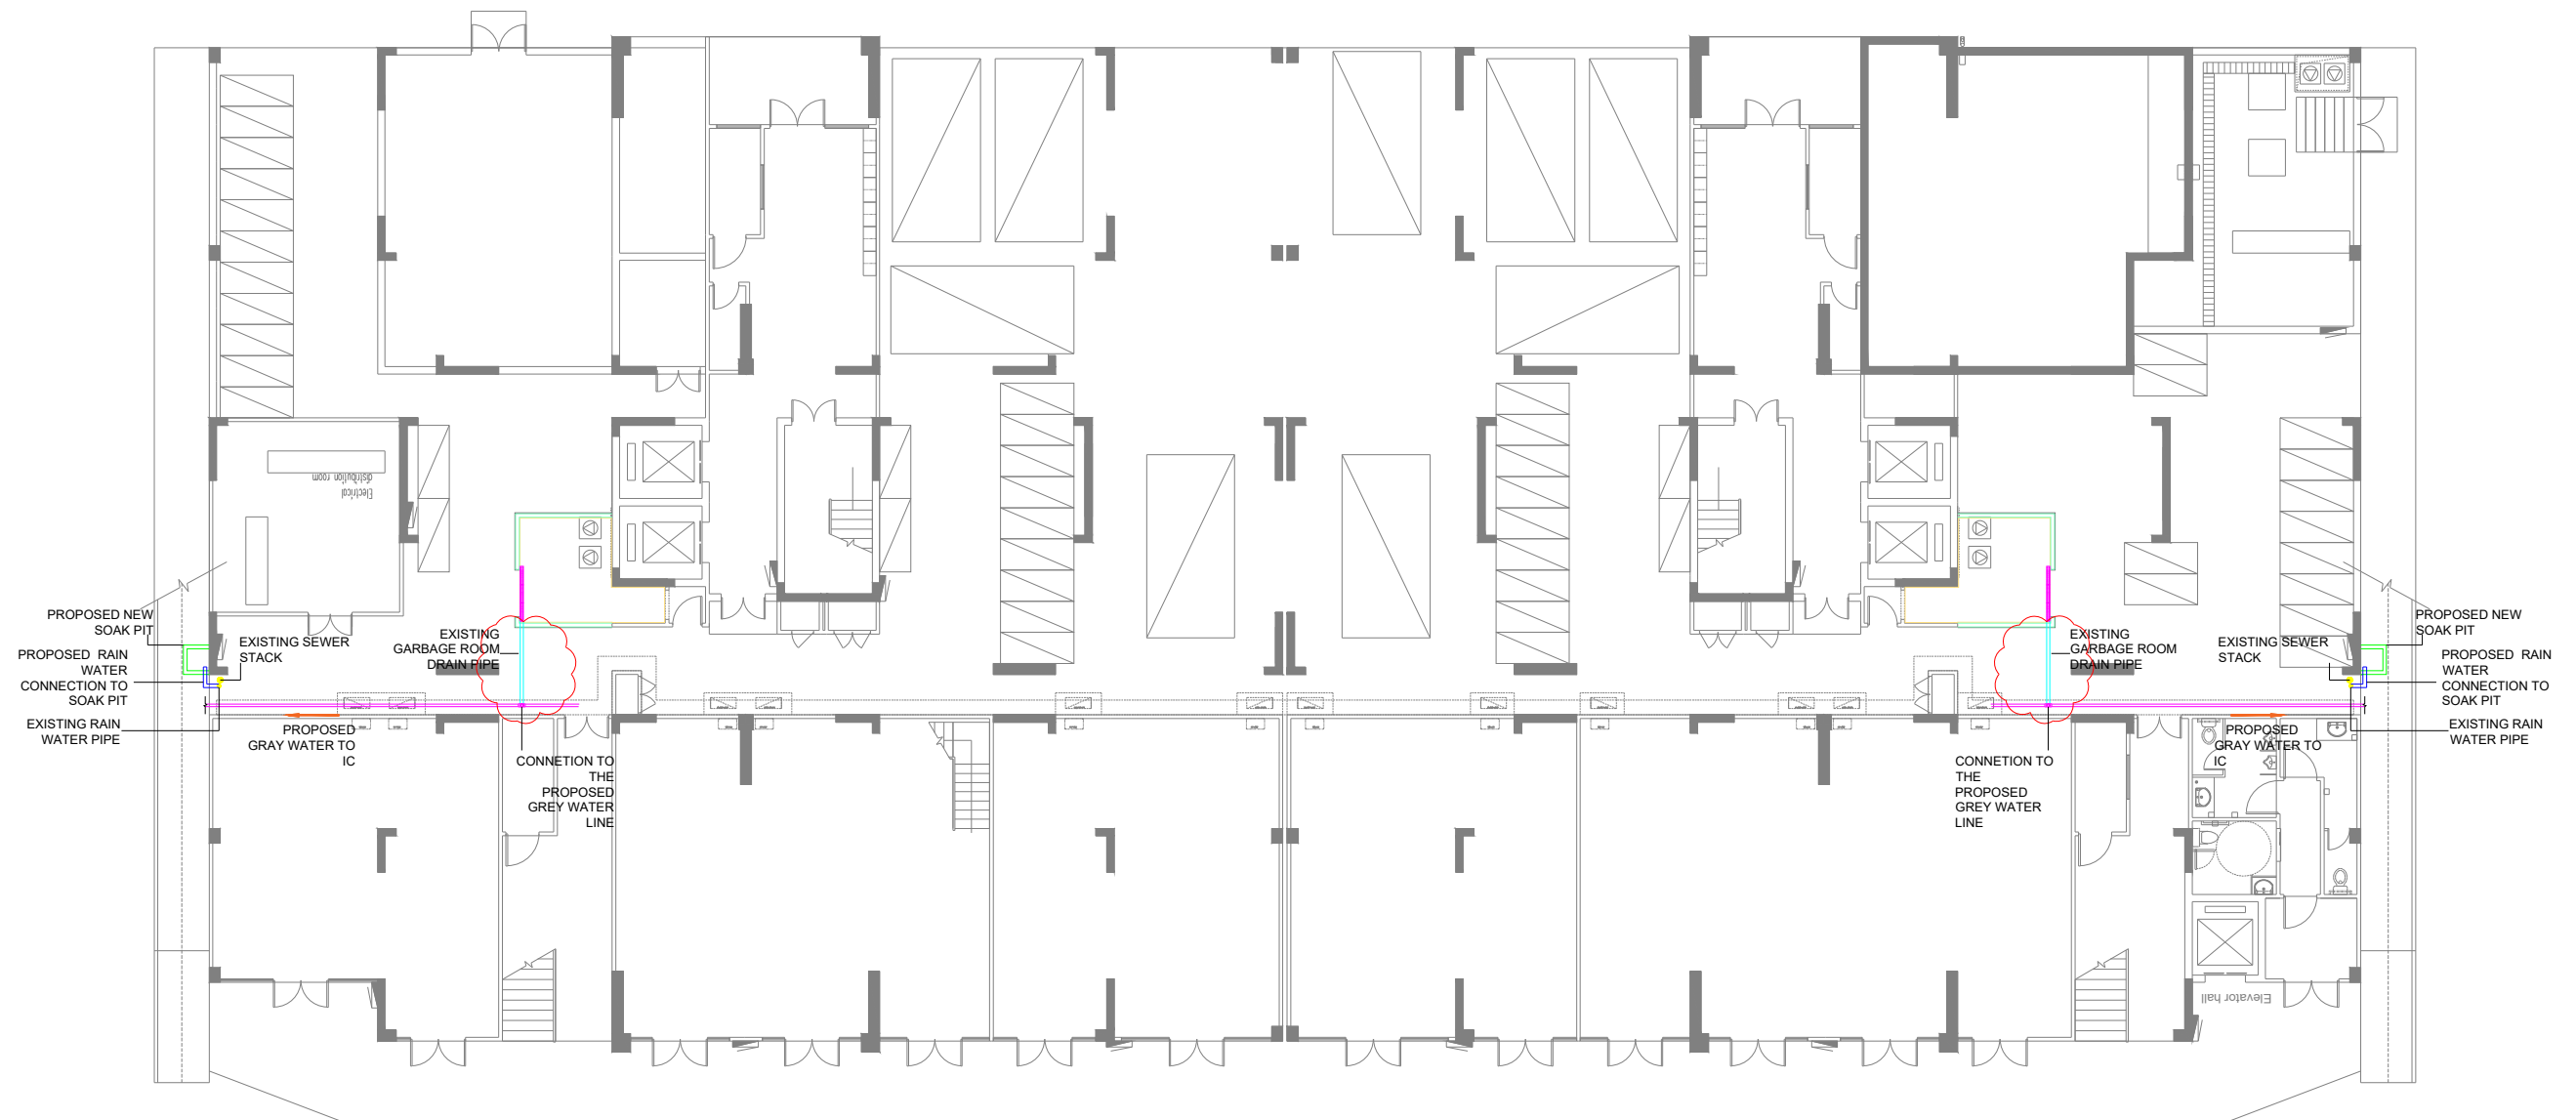

 PROPOSED GROUND FLOOR PLAN - BUILDING V9



LEGEND:

- PROPOSED GRAY WATER PIPE
- ⊓ REDUCER TEE 65mm * 50mm (TAPPING POINT)
- PROPOSED RAINWATER PIPE CONNECTION TO NEW SOAKPIT
- EXISTING DRAIN PIPE FROM GARBAGE ROOM
- PROPOSED NEW SOAK PIT

NOTE:

- All proposed pipes are UPVC
- Re-purpose the existing soak pits



**VINARES COMMERCIAL
SEWER PROVISION
HULHUMALE'**

PLANNING AND DEVELOPMENT DEPARTMENT
THIRD FLOOR, HDC BUILDING HULHUMALE'
REPUBLIC OF MALDIVES
TEL. +(960)3353535, FAX +(960)3358892
EMAIL : planning@hdc.com.mv

The drawings, concept and design contained are the properties of HDC. Use of any kind or copy of whole or part of this drawing, concept or design or use on other projects or sites other than that specified on this drawing is strictly prohibited.

DOCUMENT ID	XXXXX-SSSSS-YYYY-(NUMBER)	VERSION	1
DOCUMENT NAME	VINARES GARBAGE ROOM DRAINAGE	REVISION	-
AUTHOR	MOHAMED NAIL	CREATED DATE	21/01/2024
LAST UPDATED BY	MOHAMED NAIL	LAST UPDATED DATE	03/04/2024
REVIEWED BY	GEORGE	REVIEWED DATE	03/04/2024
APPROVED BY	MOHAMED YAMIN	APPROVED DATE	16/07/2023
INFORMATION CLASSIFICATION SCHEME	(Public, Open, Confidential, Confidential & Sensitive and Secret)		


REVISION HISTORY			
VER.	DATE	REV.	REVISION
X	DD/MM/YYYY	Z	(DRAFT)
X	DD/MM/YYYY	Z	(FEEDBACK FORMS INCLUDED)
X	DD/MM/YYYY	Z	(MODIFIED FEEDBACK FORMS)
X	DD/MM/YYYY	Z	(REFORMATTED FEEDBACK FORM)

ARCHITECT	NAIL
STRUCTURAL ENG.	YAMIN
MECHANICAL ENG.	GEORGE
ELECTRICAL ENG.	NAME
SCALE	AS GIVEN

SHEET CONTENT	----

SHEET NO.

A10

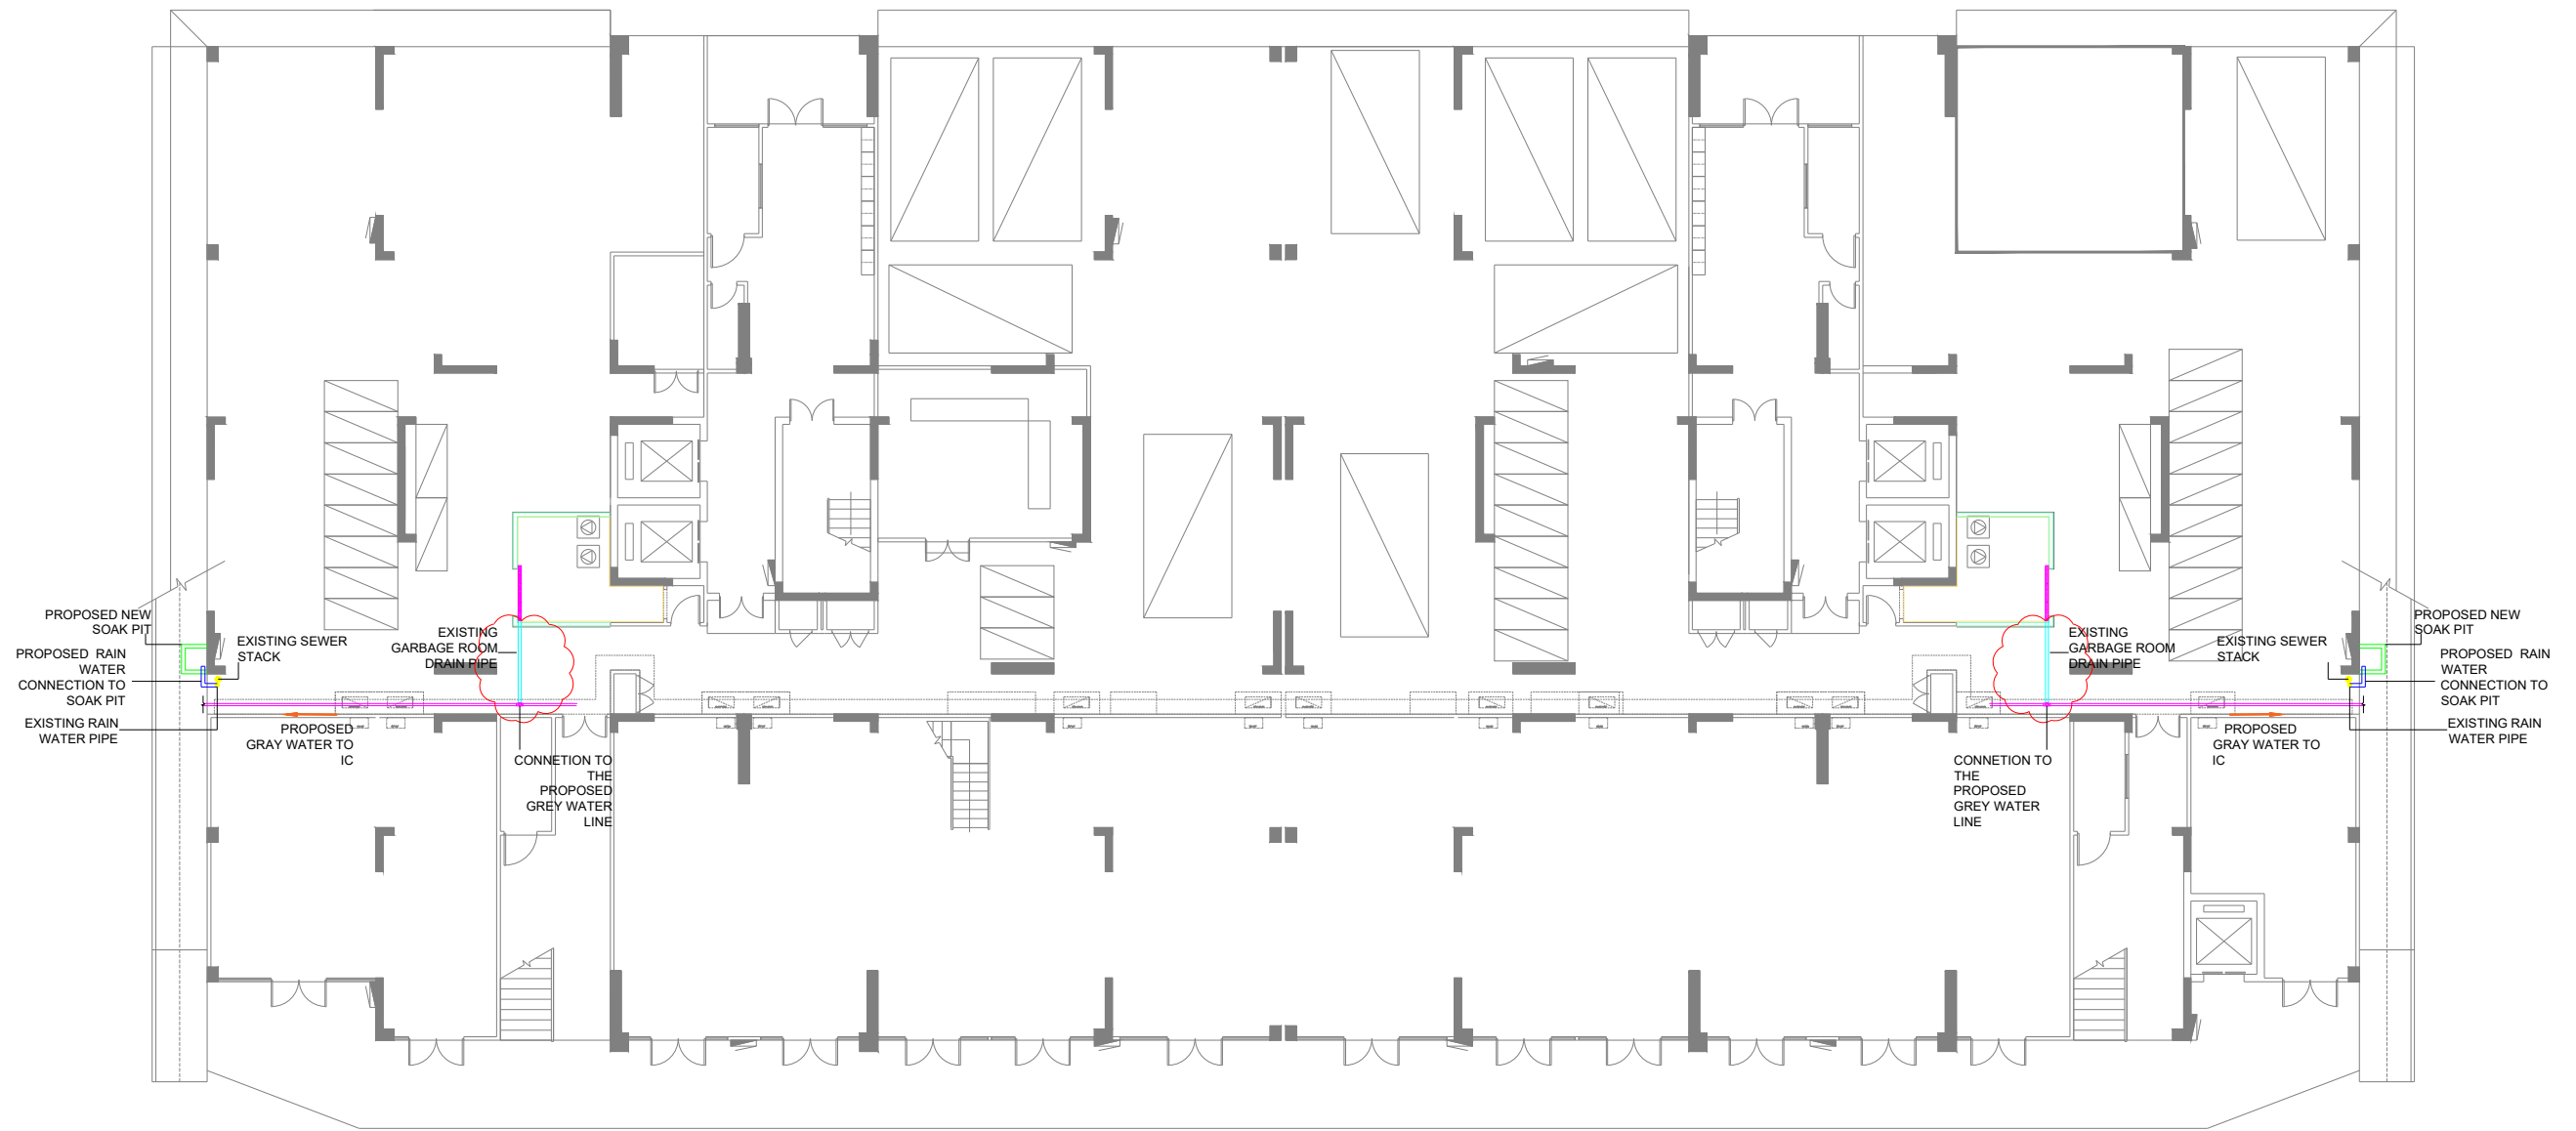

PROPOSED GROUND FLOOR PLAN - BUILDING V10
SCALE 1:200



LEGEND:

- PROPOSED GRAY WATER PIPE
- ⌋ REDUCER TEE 65mm * 50mm (TAPPING POINT)
- PROPOSED RAINWATER PIPE CONNECTION TO NEW SOAKPIT
- EXISTING DRAIN PIPE FROM GARBAGE ROOM
- PROPOSED NEW SOAK PIT

NOTE:
 - All proposed pipes are UPVC
 - Re-purpose the existing soak pits



VINARES COMMERCIAL
SEWER PROVISION
HULHUMALE'

PLANNING AND DEVELOPMENT DEPARTMENT
THIRD FLOOR, HDC BUILDING HULHUMALE'
REPUBLIC OF MALDIVES
TEL. +(960)3353535, FAX +(960)3358892
EMAIL : planning@hdc.com.mv

The drawings, concept and design contained are the properties of HDC. Use of any kind or copy of whole or part of this drawing, concept or design or use on other projects or sites other than that specified on this drawing is strictly prohibited.

DOCUMENT ID	XXXX-SSSS-YYYY-(NUMBER)	VERSION	1
DOCUMENT NAME	VINARES GARBAGE ROOM DRAINAGE	REVISION	-
AUTHOR	MOHAMED NAIL	CREATED DATE	21/01/2024
LAST UPDATED BY	MOHAMED NAIL	LAST UPDATED DATE	03/04/2024
REVIEWED BY	GEORGE	REVIEWED DATE	03/04/2024
APPROVED BY	MOHAMED YAMIN	APPROVED DATE	16/07/2023
INFORMATION CLASSIFICATION SCHEME	(Public, Open, Confidential, Confidential & Sensitive and Secret)		

REVISION HISTORY			
VER.	DATE	REV.	REVISION
X	DD/MM/YYYY	Z	(DRAFT)
X	DD/MM/YYYY	Z	(FEEDBACK FORMS INCLUDED)
X	DD/MM/YYYY	Z	(MODIFIED FEEDBACK FORMS)
X	DD/MM/YYYY	Z	(REFORMATTED FEEDBACK FORM)

ARCHITECT	NAIL
STRUCTURAL ENG.	YAMIN
MECHANICAL ENG.	GEORGE
ELECTRICAL ENG.	NAME
SCALE	AS GIVEN

SHEET CONTENT	----

SHEET NO.

A11