



VINARES GARBAGE ROOM AS-BUILT
DRAWINGS

VINARES COMMERCIAL
ARCHITECTURAL / SERVICES DRAWING
04 MARCH 2024



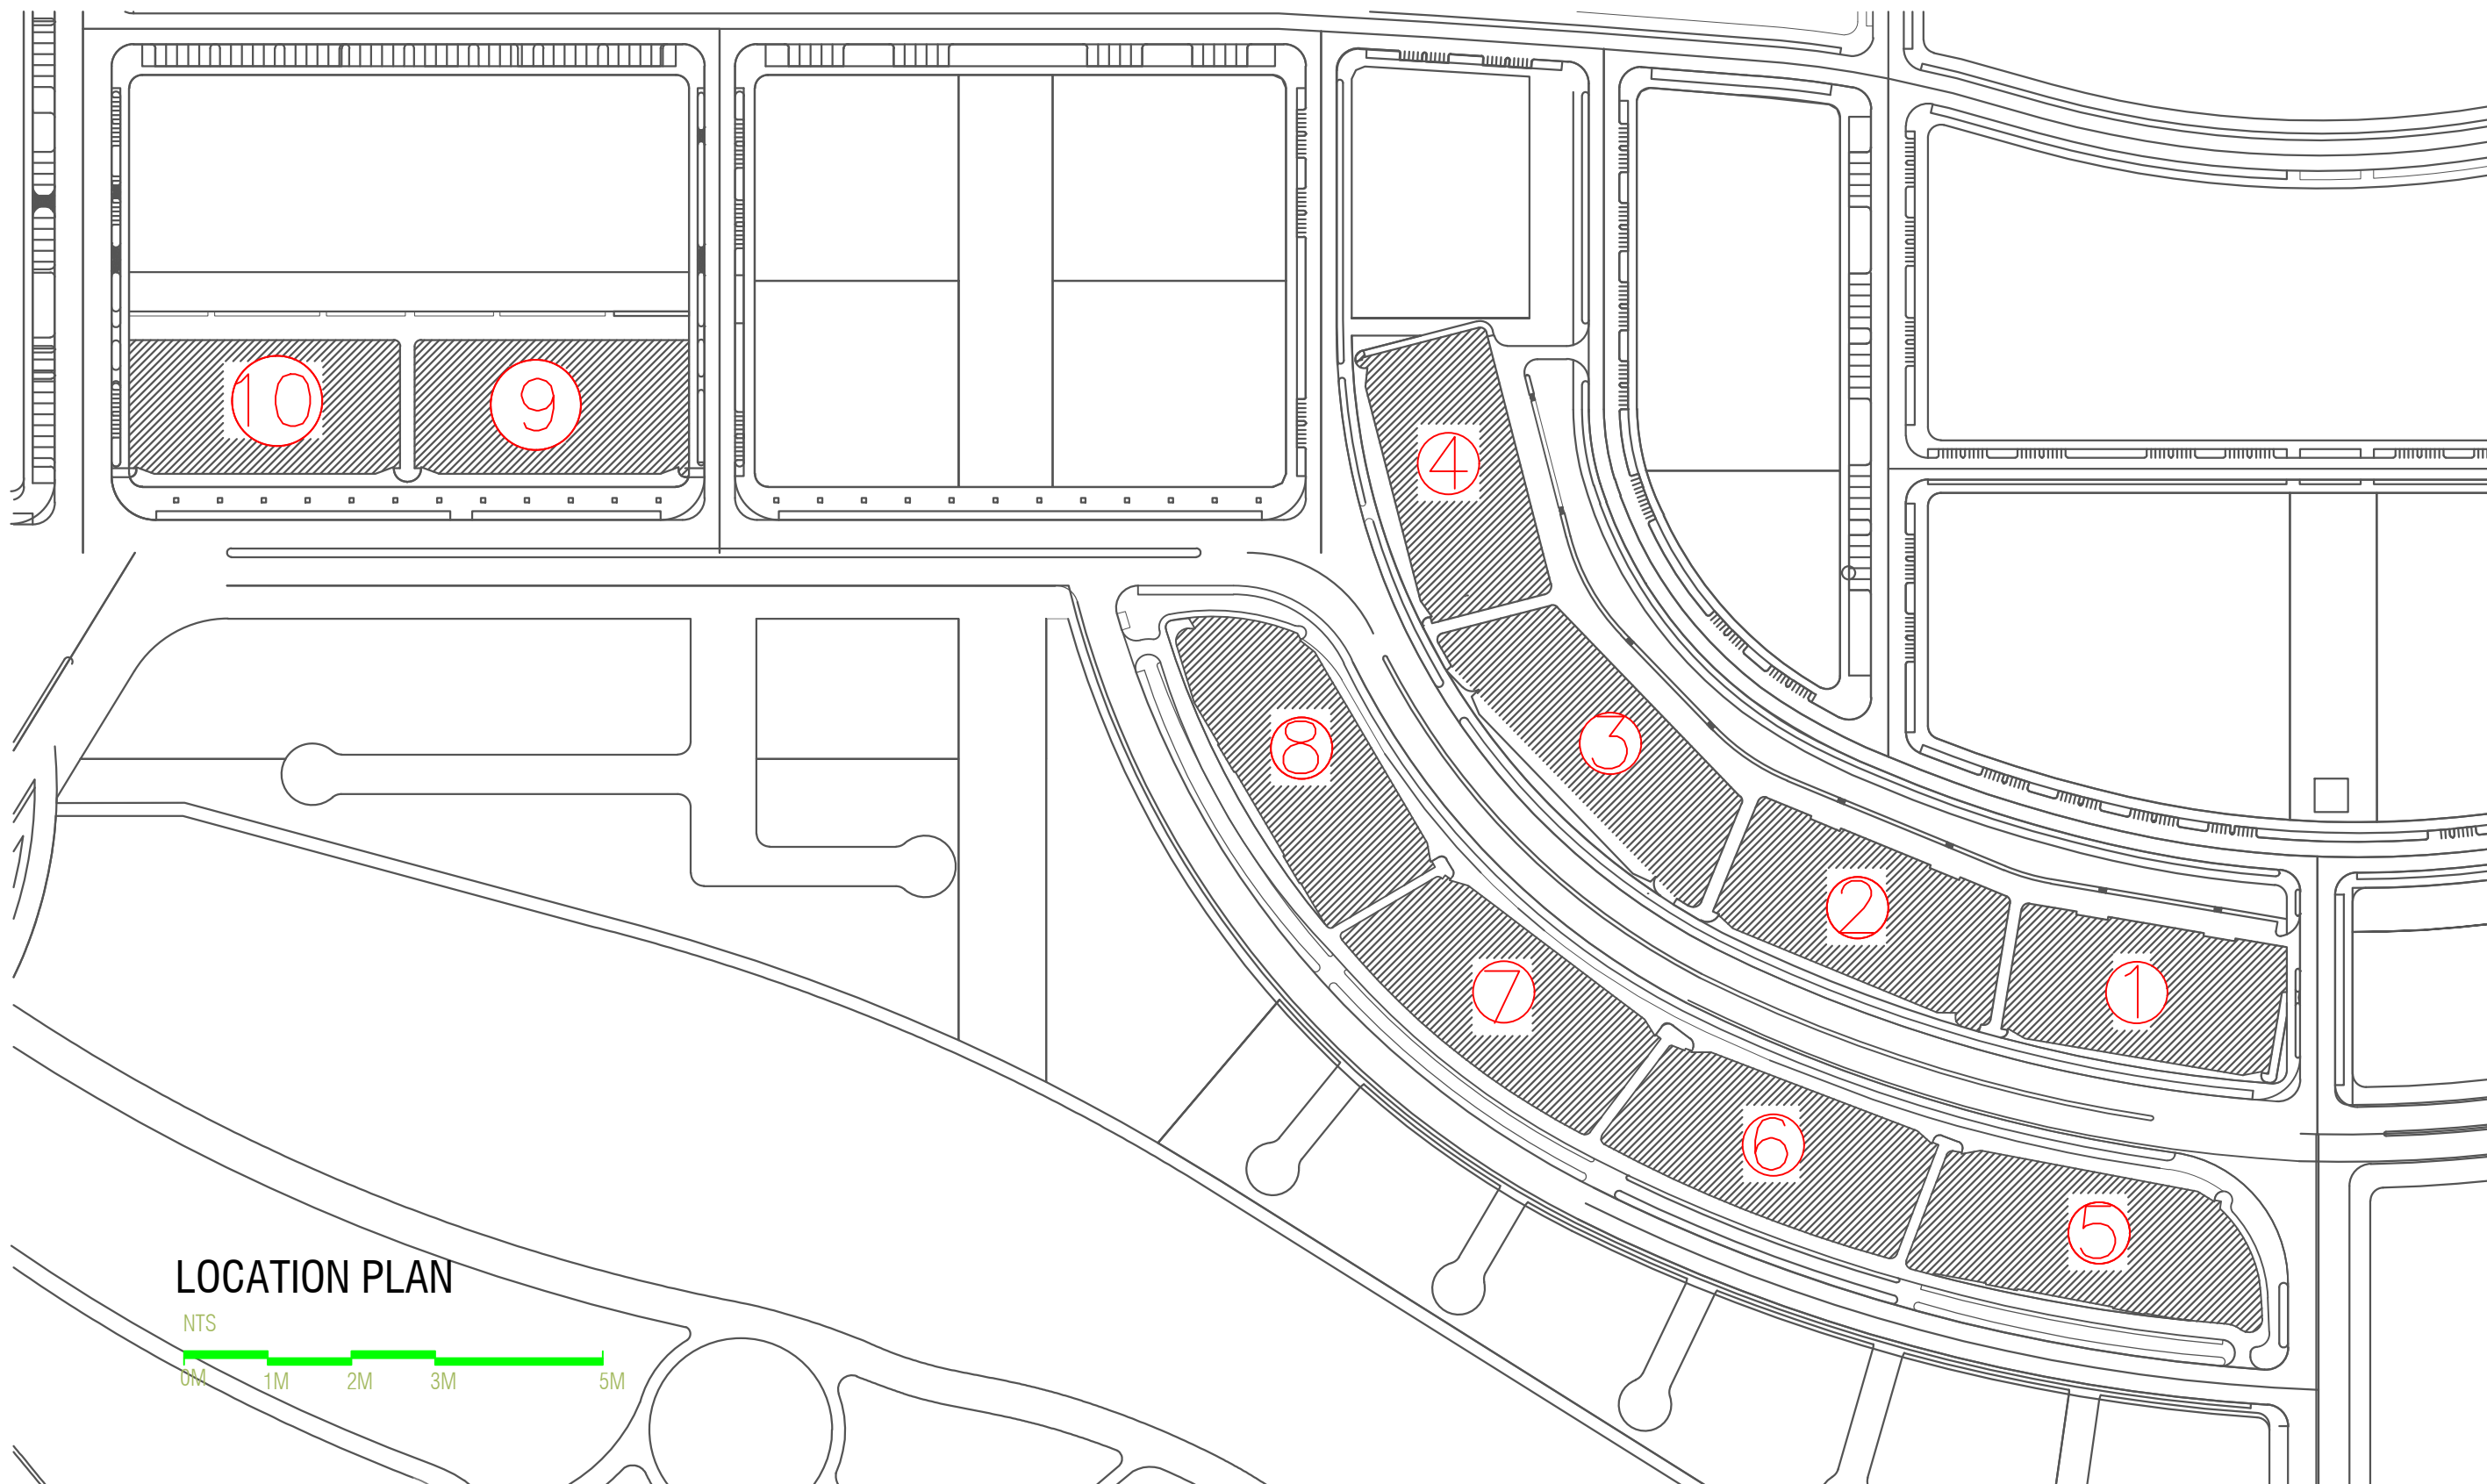

 LOCATION PLAN



PLANNING AND DEVELOPMENT DEPARTMENT
 THIRD FLOOR, HDC BUILDING HULHUMALE'
 REPUBLIC OF MALDIVES
 TEL. +(960)3353535, FAX +(960)3358892
 EMAIL : planning@hdc.com.mv

**VINARES COMMERCIAL
 SEWER PROVISION
 HULHUMALE'**

The drawings, concept and design contained are the properties of HDC. Use of any kind or copy of whole or part of this drawing, concept or design or use on other projects or sites other than that specified on this drawing is strictly prohibited.


DOCUMENT ID	XXXX-SSSS-YYYY-(NUMBER)	VERSION	1
DOCUMENT NAME	VINARES GARBAGE ROOM DRAINAGE	REVISION	-
AUTHOR	MOHAMED NAIL	CREATED DATE	21/01/2024
LAST UPDATED BY	MOHAMED NAIL	LAST UPDATED DATE	03/04/2024
REVIEWED BY	GEORGE	REVIEWED DATE	03/04/2024
APPROVED BY	MOHAMED YAMIN	APPROVED DATE	16/07/2023
INFORMATION CLASSIFICATION SCHEME	[Public, Open, Confidential, Confidential & Sensitive and Secret]		

REVISION HISTORY			
VER.	DATE	REV.	REVISION
X	DD/MM/YYYY	Z	(DRAFT)
X	DD/MM/YYYY	Z	(FEEDBACK FORMS INCLUDED)
X	DD/MM/YYYY	Z	(MODIFIED FEEDBACK FORMS)
X	DD/MM/YYYY	Z	(REFORMATTED FEEDBACK FORM)

ARCHITECT	NAIL
STRUCTURAL ENG.	YAMIN
MECHANICAL ENG.	GEORGE
ELECTRICAL ENG.	NAME
SCALE	AS GIVEN

SHEET CONTENT	----

SHEET NO.
A01

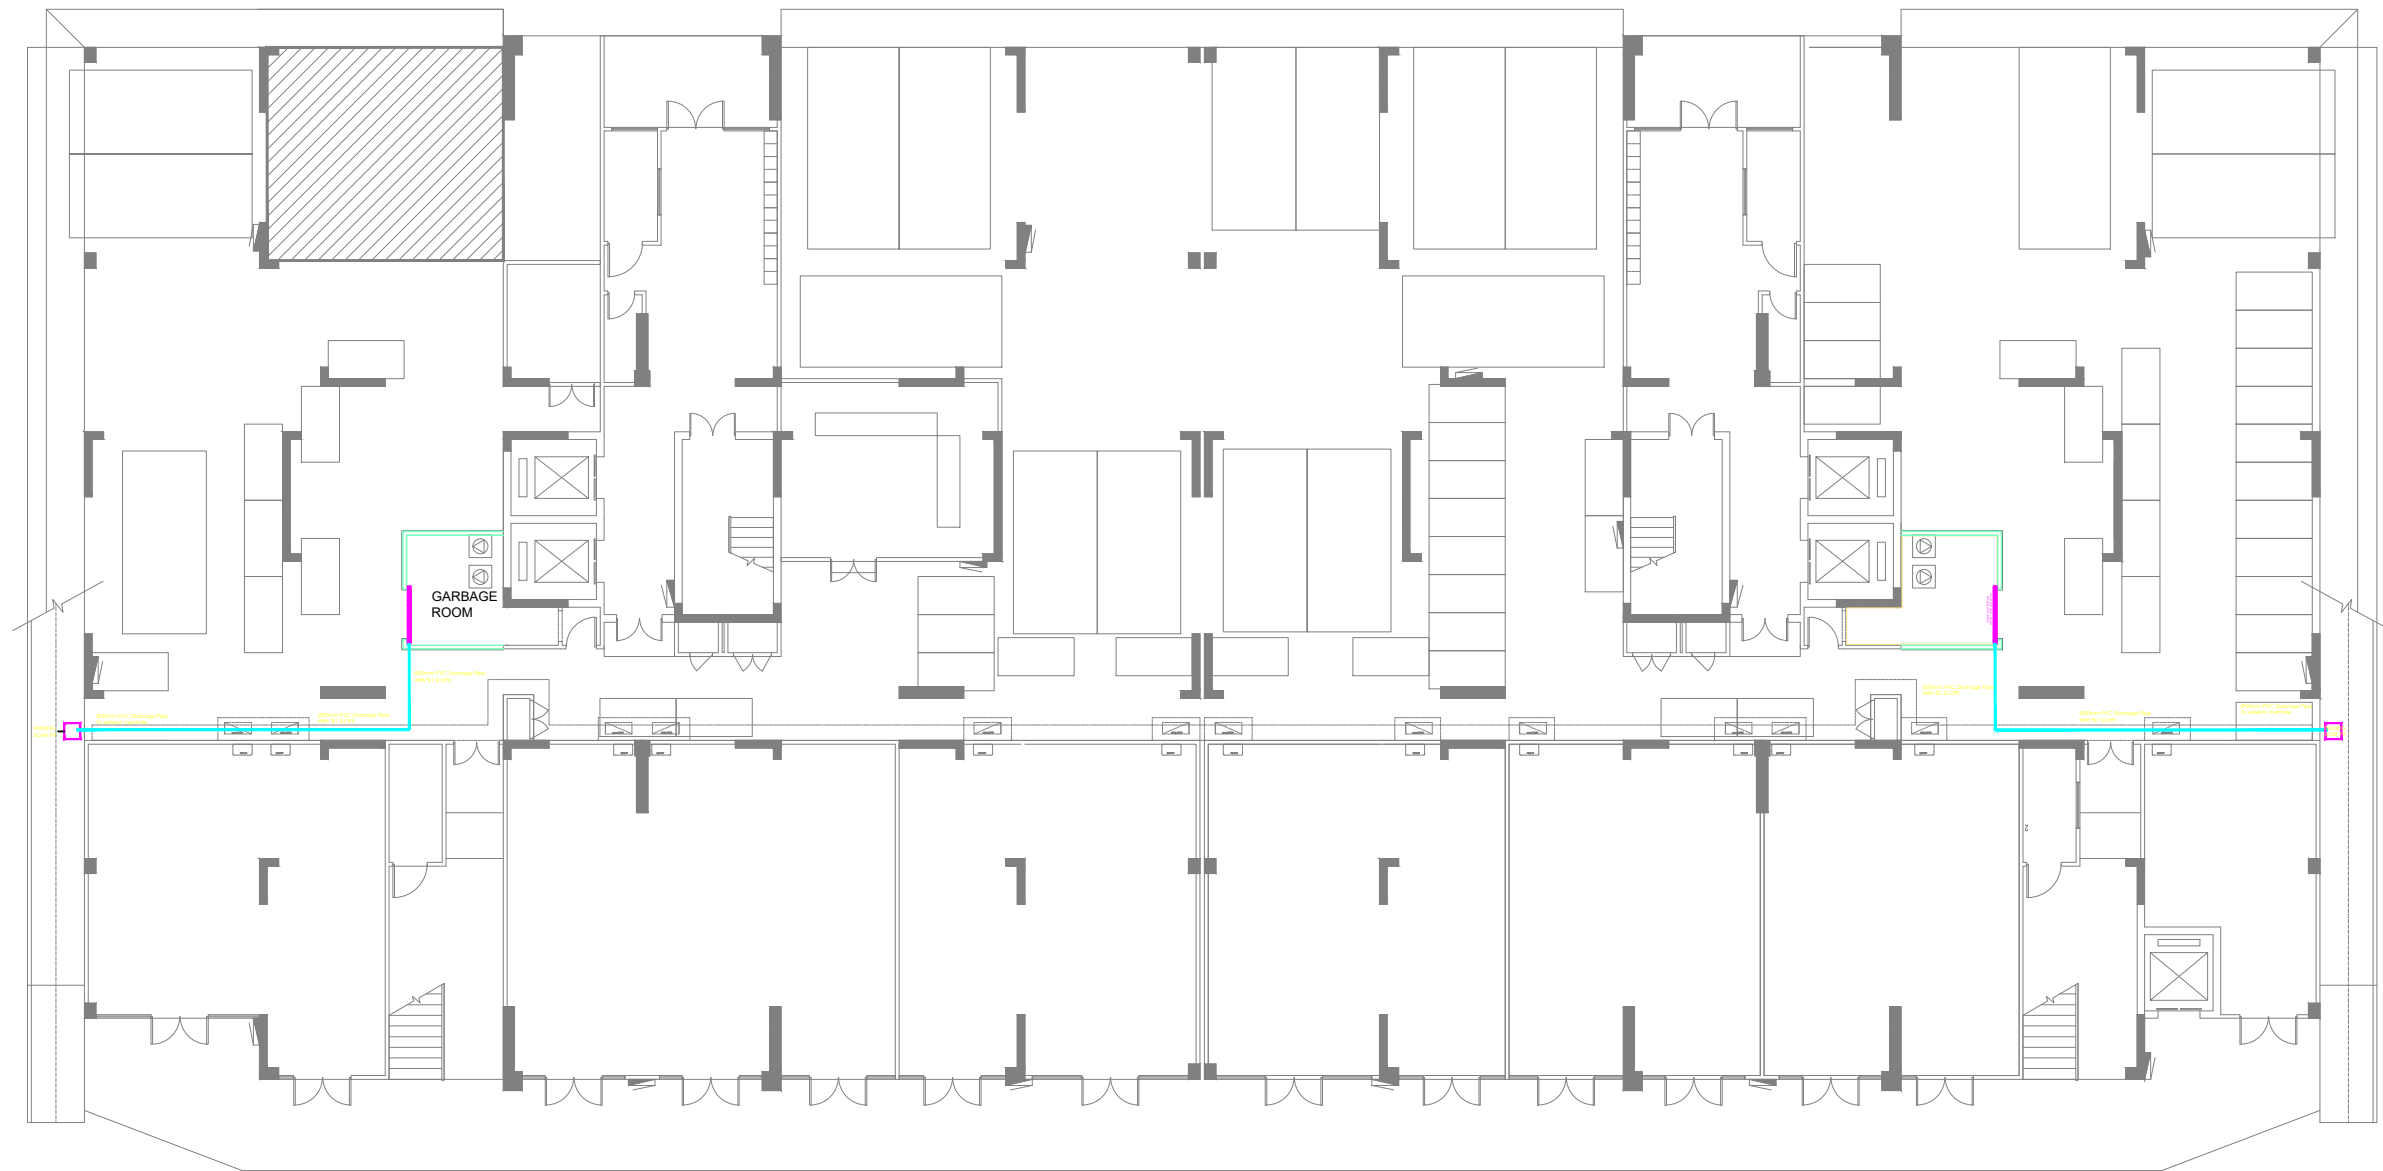

SYMBOL	DESCRIPTION
	DRAINAGE LINE - PVC LOW PRESSURE
	LINEAR FLOOR DRAIN- LxWxD: 1500x150x125mm
	EXISTING SOAK PIT

AS-BUILT OF GROUND FLOOR PLAN - BUILDING V1

SCALE 1:200



PLANNING AND DEVELOPMENT DEPARTMENT
THIRD FLOOR, HDC BUILDING HULHUMALE'
REPUBLIC OF MALDIVES
TEL. +(960)3353535, FAX +(960)3358892
EMAIL : planning@hdc.com.mv

VINARES COMMERCIAL SEWER PROVISION HULHUMALE'

The drawings, concept and design contained are the properties of HDC. Use of any kind or copy of whole or part of this drawing, concept or design or use on other projects or sites other than that specified on this drawing is strictly prohibited.

DOCUMENT ID	XXXXX-SSSSS-YYYY-(NUMBER)	VERSION	1
DOCUMENT NAME	VINARES GARBAGE ROOM DRAINAGE	REVISION	-
AUTHOR	MOHAMED NAIL	CREATED DATE	21/01/2024
LAST UPDATED BY	MOHAMED NAIL	LAST UPDATED DATE	03/04/2024
REVIEWED BY	GEORGE	REVIEWED DATE	03/04/2024
APPROVED BY	MOHAMED YAMIN	APPROVED DATE	16/07/2023
INFORMATION CLASSIFICATION SCHEME	(Public, Open, Confidential, Confidential & Sensitive and Secret)		


REVISION HISTORY			
VER.	DATE	REV.	REVISION
X	DD/MM/YYYY	Z	(DRAFT)
X	DD/MM/YYYY	Z	(FEEDBACK FORMS INCLUDED)
X	DD/MM/YYYY	Z	(MODIFIED FEEDBACK FORMS)
X	DD/MM/YYYY	Z	(REFORMATTED FEEDBACK FORM)

ARCHITECT	NAIL
STRUCTURAL ENG.	YAMIN
MECHANICAL ENG.	GEORGE
ELECTRICAL ENG.	NAME
SCALE	AS GIVEN

SHEET CONTENT

SHEET NO.

A02

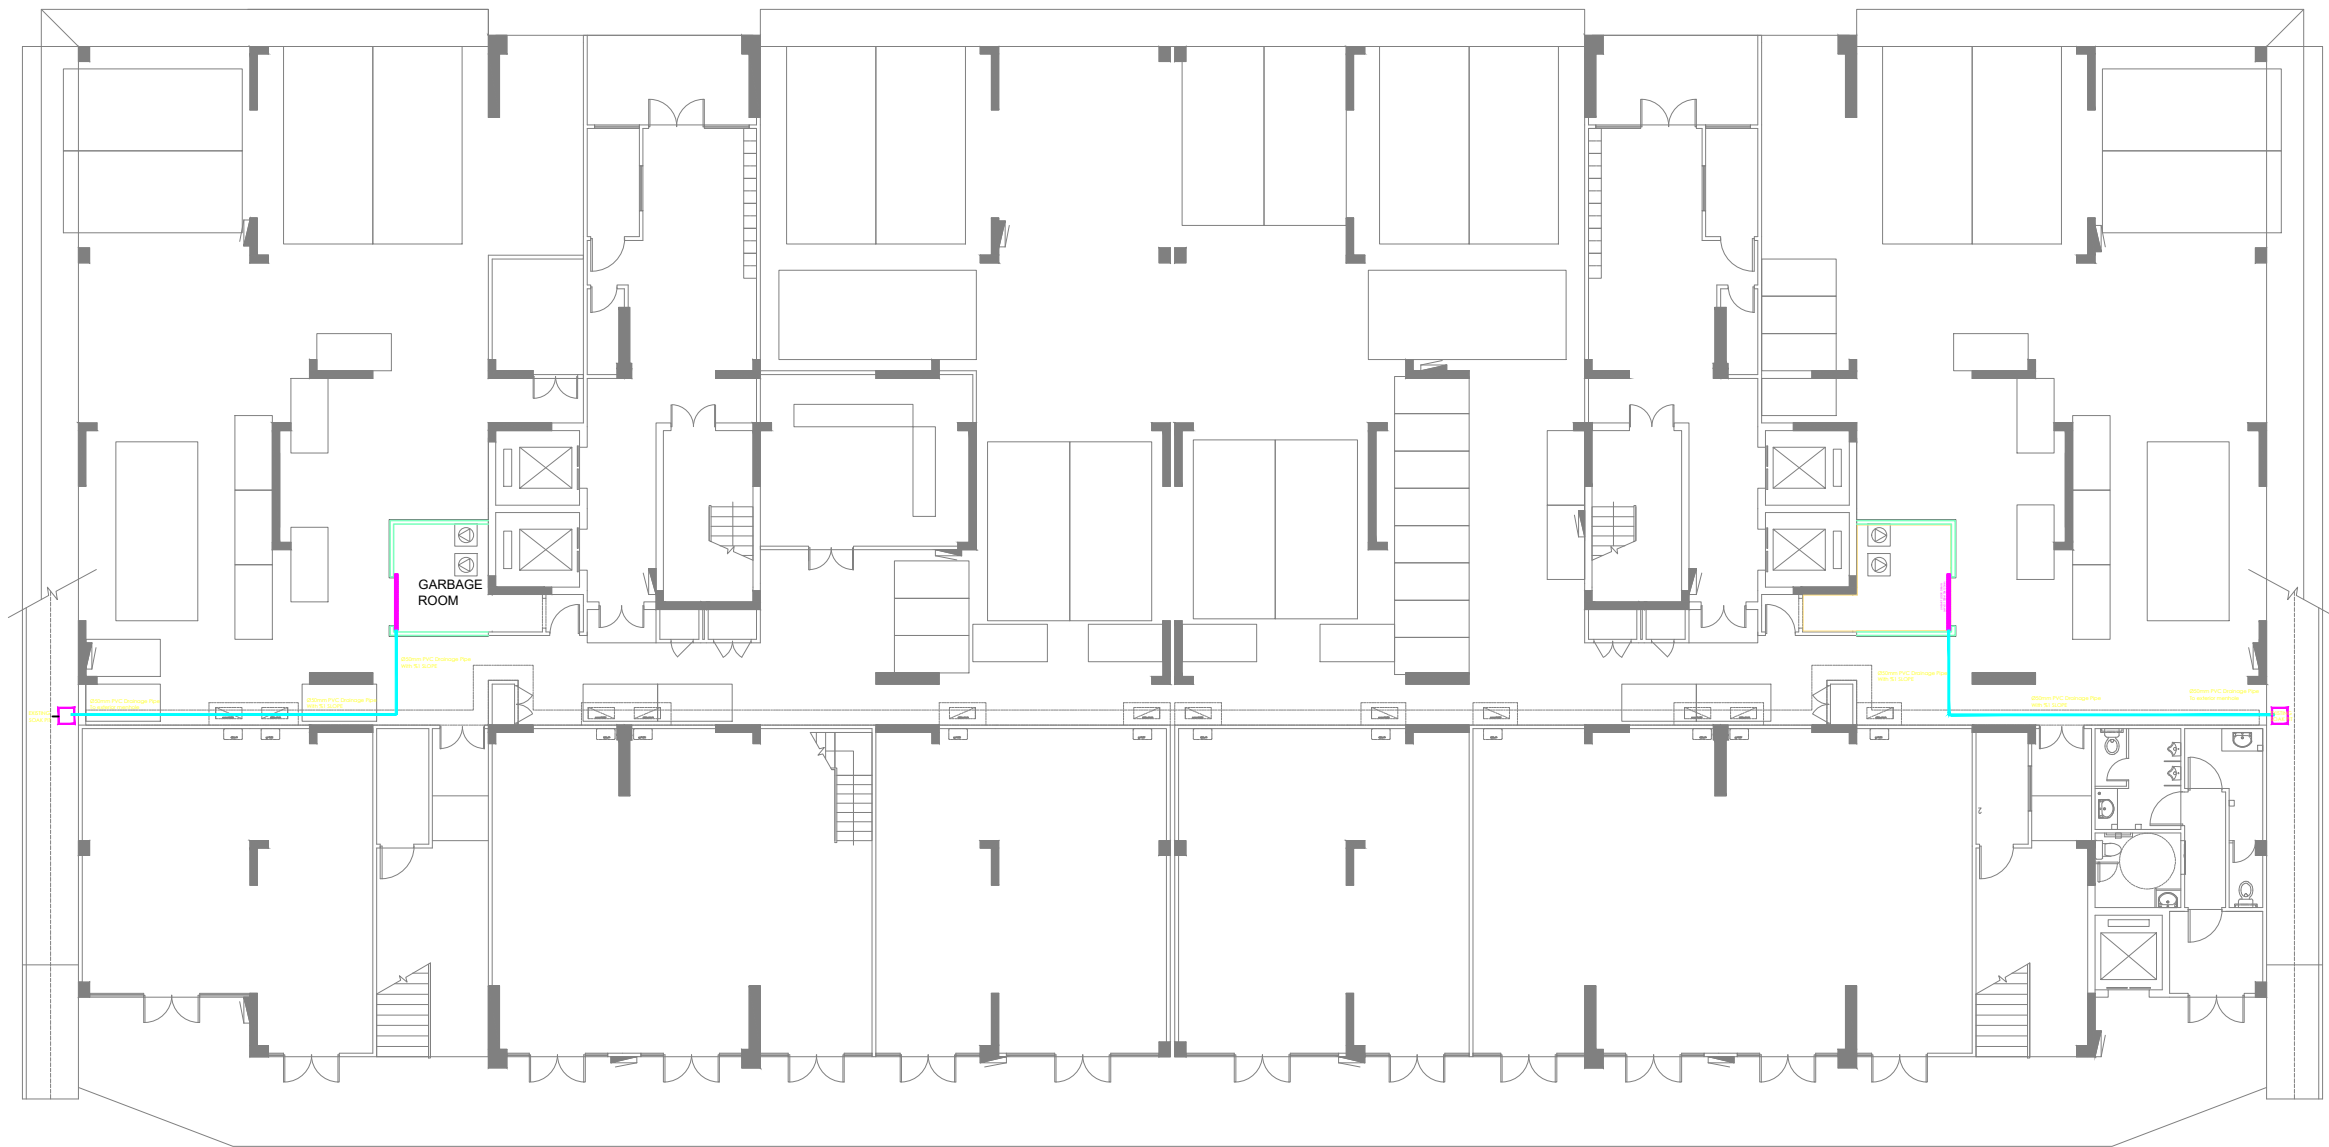

SYMBOL	DESCRIPTION
	DRAINAGE LINE - PVC LOW PRESSURE
	LINEAR FLOOR DRAIN- LxWxD: 1500x150x125mm
	EXISTING SOAK PIT

AS-BUILT OF GROUND FLOOR PLAN - BUILDING V2

SCALE 1:200



PLANNING AND DEVELOPMENT DEPARTMENT
THIRD FLOOR, HDC BUILDING HULHUMALE'
REPUBLIC OF MALDIVES
TEL. +(960)3353535, FAX +(960)3358892
EMAIL : planning@hdc.com.mv

VINARES COMMERCIAL SEWER PROVISION HULHUMALE'

The drawings, concept and design contained are the properties of HDC. Use of any kind or copy of whole or part of this drawing, concept or design or use on other projects or sites other than that specified on this drawing is strictly prohibited.


DOCUMENT ID	XXXXX-SSSS-YYYY-(NUMBER)	VERSION	1
DOCUMENT NAME	VINARES GARBAGE ROOM DRAINAGE	REVISION	-
AUTHOR	MOHAMED NAIL	CREATED DATE	21/01/2024
LAST UPDATED BY	MOHAMED NAIL	LAST UPDATED DATE	03/04/2024
REVIEWED BY	GEORGE	REVIEWED DATE	03/04/2024
APPROVED BY	MOHAMED YAMIN	APPROVED DATE	16/07/2023
INFORMATION CLASSIFICATION SCHEME	(Public, Open, Confidential, Confidential & Sensitive and Secret)		

REVISION HISTORY			
VER.	DATE	REV.	REVISION
X	DD/MM/YYYY	Z	(DRAFT)
X	DD/MM/YYYY	Z	(FEEDBACK FORMS INCLUDED)
X	DD/MM/YYYY	Z	(MODIFIED FEEDBACK FORMS)
X	DD/MM/YYYY	Z	(REFORMATTED FEEDBACK FORM)

ARCHITECT	NAIL
STRUCTURAL ENG.	YAMIN
MECHANICAL ENG.	GEORGE
ELECTRICAL ENG.	NAME
SCALE	AS GIVEN

SHEET CONTENT

SHEET NO.
A03

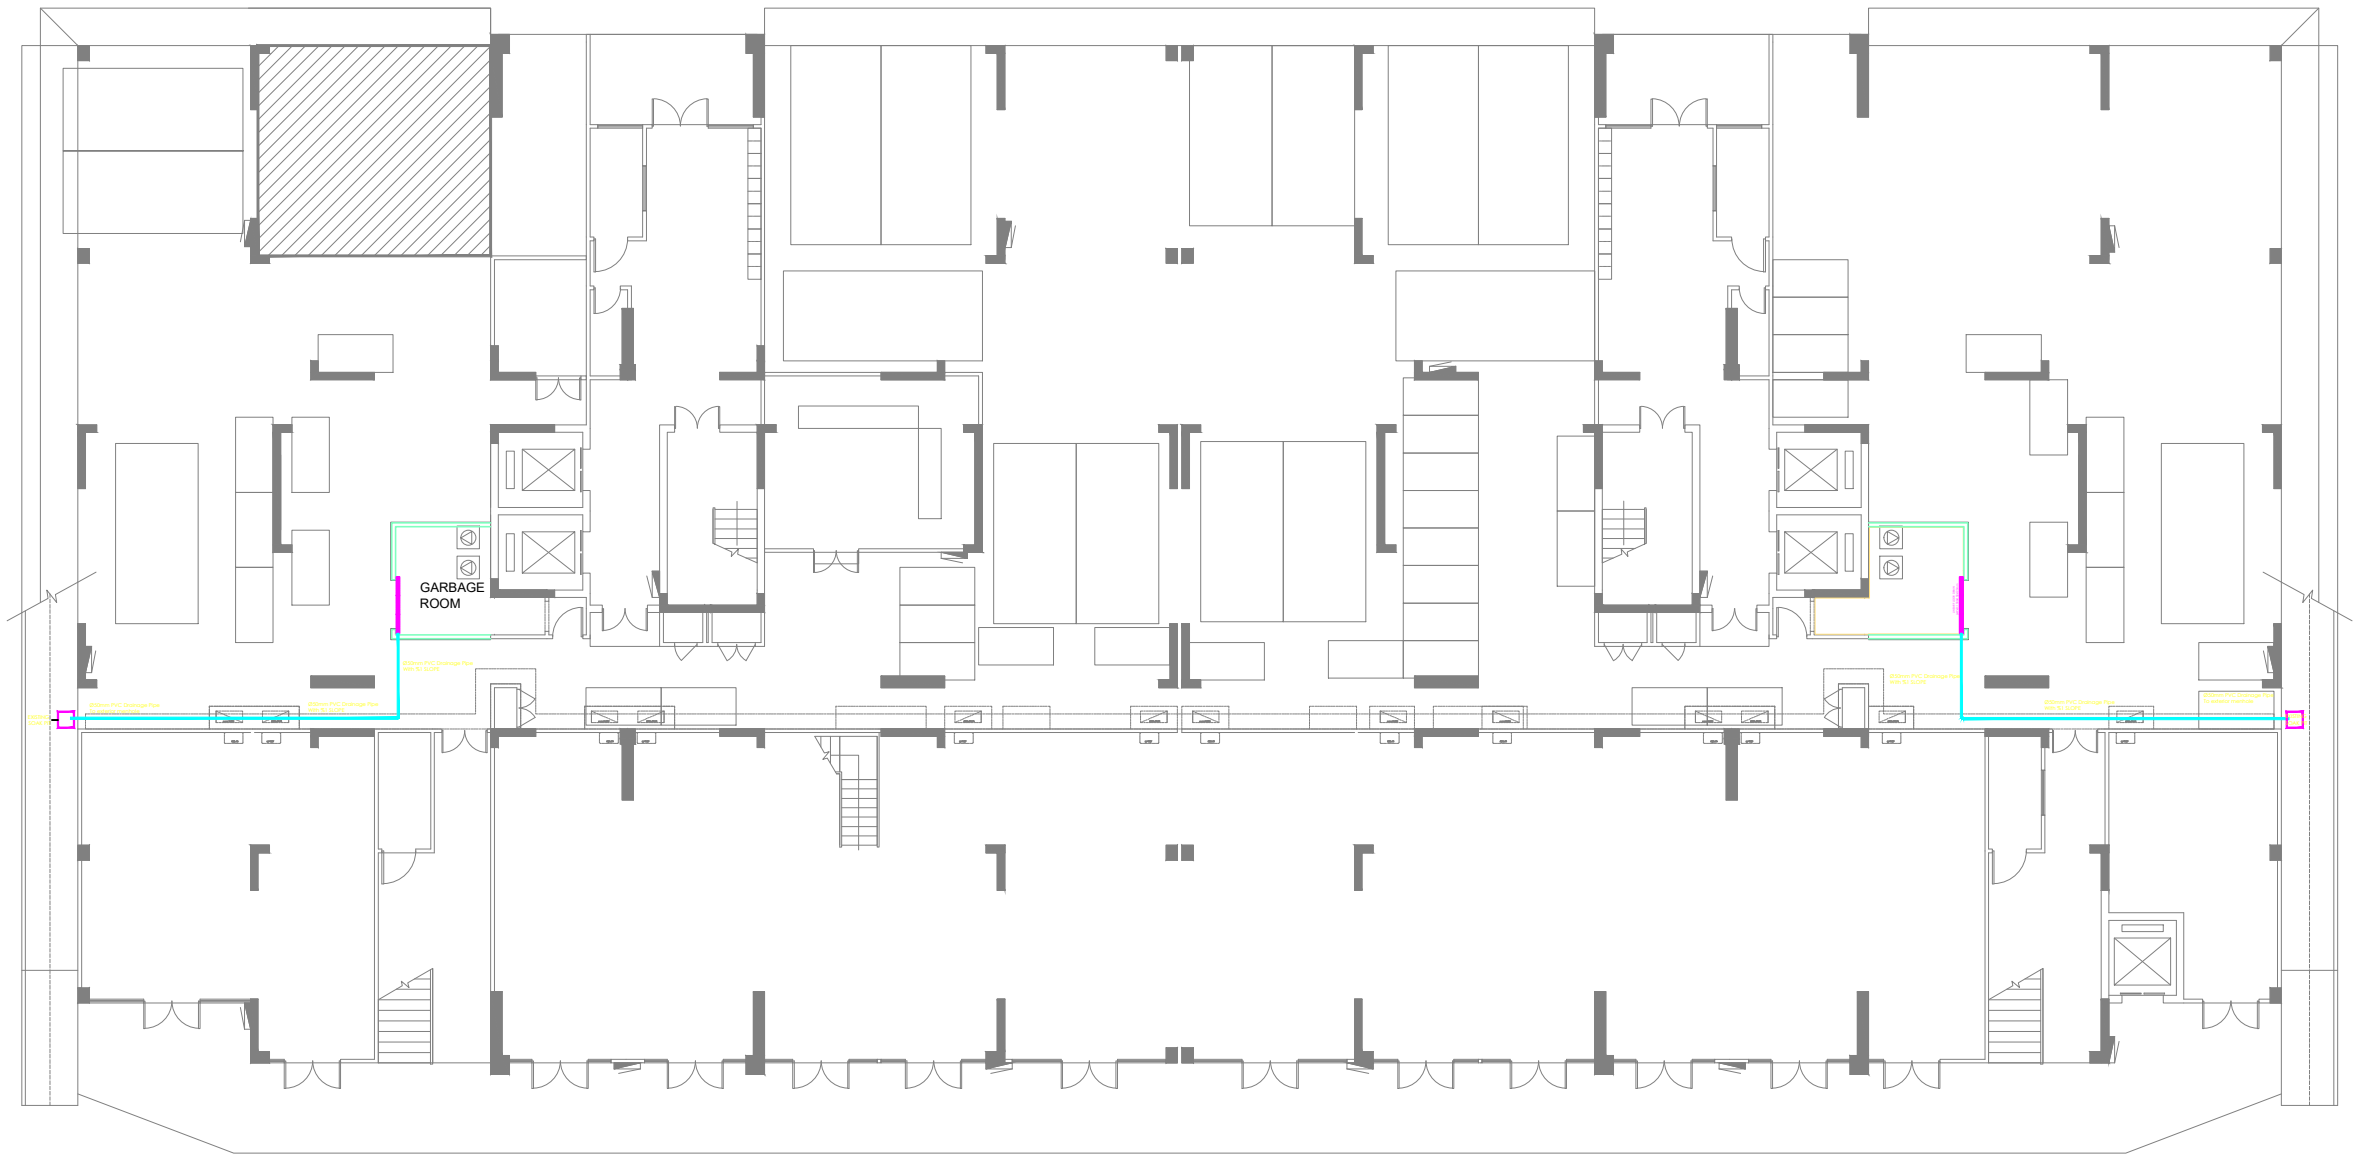

SYMBOL	DESCRIPTION
	DRAINAGE LINE - PVC LOW PRESSURE
	LINEAR FLOOR DRAIN- LxWd: 1500x150x125mm
	EXISTING SOAK PIT

AS-BUILT OF GROUND FLOOR PLAN - BUILDING V3

SCALE 1:200



PLANNING AND DEVELOPMENT DEPARTMENT
THIRD FLOOR, HDC BUILDING HULHUMALE'
REPUBLIC OF MALDIVES
TEL. +(960)3353535, FAX +(960)3358892
EMAIL : planning@hdc.com.mv

VINARES COMMERCIAL SEWER PROVISION HULHUMALE'

The drawings, concept and design contained are the properties of HDC. Use of any kind or copy of whole or part of this drawing, concept or design or use on other projects or sites other than that specified on this drawing is strictly prohibited.

DOCUMENT ID	XXXX-SSSS-YYYY-(NUMBER)	VERSION	1
DOCUMENT NAME	VINARES GARBAGE ROOM DRAINAGE	REVISION	-
AUTHOR	MOHAMED NAIL	CREATED DATE	21/01/2024
LAST UPDATED BY	MOHAMED NAIL	LAST UPDATED DATE	03/04/2024
REVIEWED BY	GEORGE	REVIEWED DATE	03/04/2024
APPROVED BY	MOHAMED YAMIN	APPROVED DATE	16/07/2023
INFORMATION CLASSIFICATION SCHEME	(Public, Open, Confidential, Confidential & Sensitive and Secret)		


REVISION HISTORY			
VER.	DATE	REV.	REVISION
X	DD/MM/YYYY	Z	(DRAFT)
X	DD/MM/YYYY	Z	(FEEDBACK FORMS INCLUDED)
X	DD/MM/YYYY	Z	(MODIFIED FEEDBACK FORMS)
X	DD/MM/YYYY	Z	(REFORMATTED FEEDBACK FORM)

ARCHITECT	NAIL
STRUCTURAL ENG.	YAMIN
MECHANICAL ENG.	GEORGE
ELECTRICAL ENG.	NAME
SCALE	AS GIVEN

SHEET CONTENT

SHEET NO.

A04

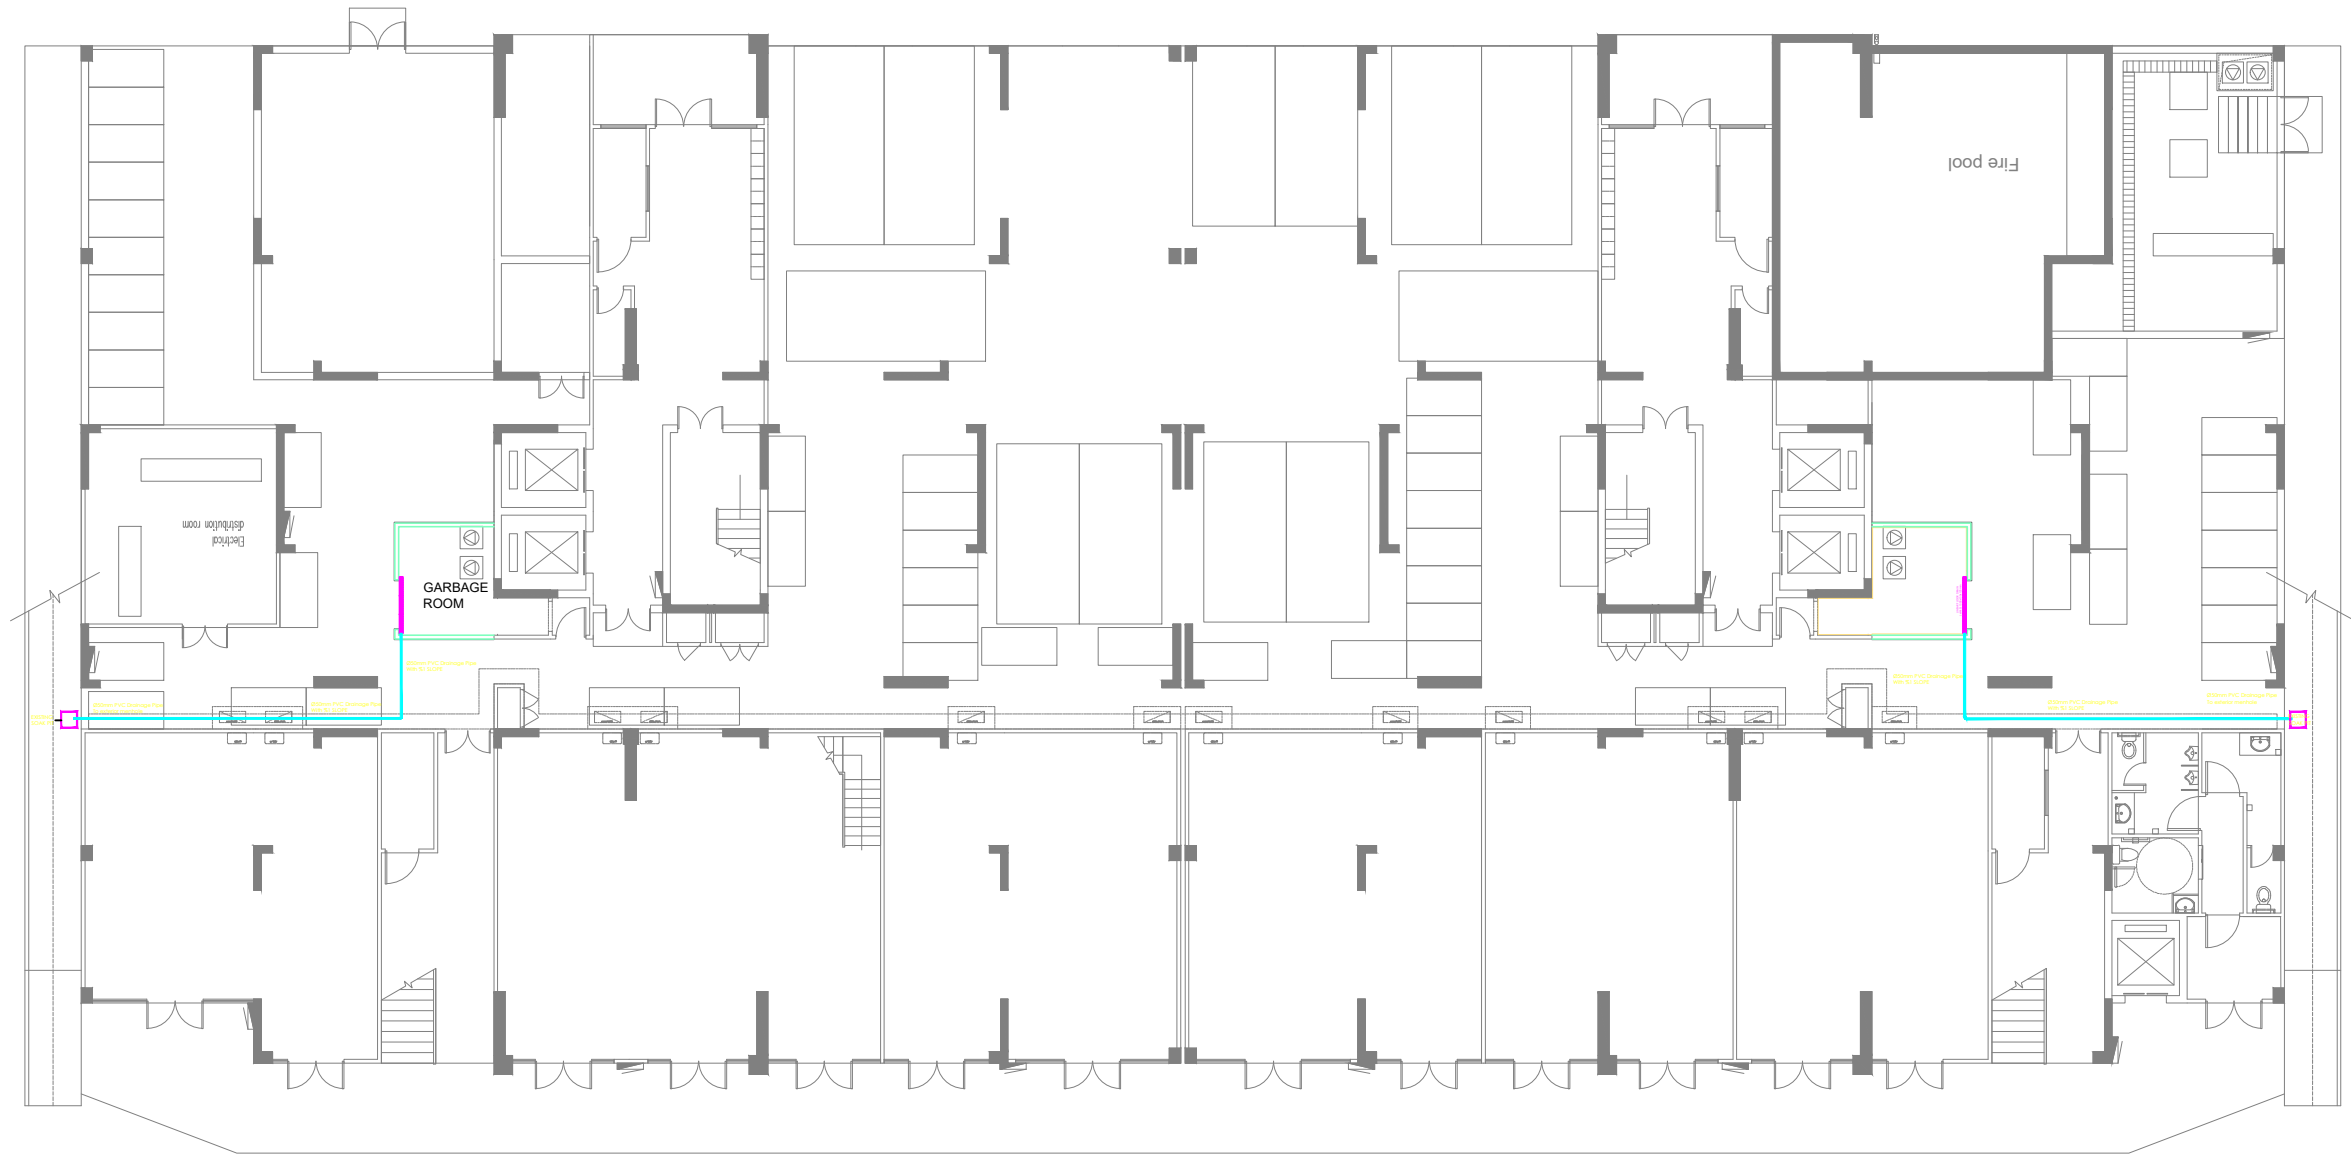

SYMBOL	DESCRIPTION
	DRAINAGE LINE - PVC LOW PRESSURE
	LINEAR FLOOR DRAIN- LxWxD: 1500x150x125mm
	EXISTING SOAK PIT

AS-BUILT OF GROUND FLOOR PLAN - BUILDING V4

SCALE 1:200



PLANNING AND DEVELOPMENT DEPARTMENT
THIRD FLOOR, HDC BUILDING HULHUMALE'
REPUBLIC OF MALDIVES
TEL. +(960)3353535, FAX +(960)3358892
EMAIL : planning@hdc.com.mv

VINARES COMMERCIAL SEWER PROVISION HULHUMALE'

The drawings, concept and design contained are the properties of HDC. Use of any kind or copy of whole or part of this drawing, concept or design or use on other projects or sites other than that specified on this drawing is strictly prohibited.

DOCUMENT ID	XXXXX-SSSSS-YYYY-(NUMBER)	VERSION	1
DOCUMENT NAME	VINARES GARBAGE ROOM DRAINAGE	REVISION	-
AUTHOR	MOHAMED NAIL	CREATED DATE	21/01/2024
LAST UPDATED BY	MOHAMED NAIL	LAST UPDATED DATE	03/04/2024
REVIEWED BY	GEORGE	REVIEWED DATE	03/04/2024
APPROVED BY	MOHAMED YAMIN	APPROVED DATE	16/07/2023
INFORMATION CLASSIFICATION SCHEME	(Public, Open, Confidential, Confidential & Sensitive and Secret)		

REVISION HISTORY			
VER.	DATE	REV.	REVISION
X	DD/MM/YYYY	Z	(DRAFT)
X	DD/MM/YYYY	Z	(FEEDBACK FORMS INCLUDED)
X	DD/MM/YYYY	Z	(MODIFIED FEEDBACK FORMS)
X	DD/MM/YYYY	Z	(REFORMATTED FEEDBACK FORM)

ARCHITECT	NAIL
STRUCTURAL ENG.	YAMIN
MECHANICAL ENG.	GEORGE
ELECTRICAL ENG.	NAME
SCALE	AS GIVEN

SHEET CONTENT

SHEET NO.

A05



AS-BUILT OF GROUND FLOOR PLAN - BUILDING V5

SCALE 1:200



SYMBOL	DESCRIPTION
	DRAINAGE LINE - PVC LOW PRESSURE
	LINEAR FLOOR DRAIN- LxWxD: 1500x150x125mm
	EXISTING SOAK PIT



PLANNING AND DEVELOPMENT DEPARTMENT
THIRD FLOOR, HDC BUILDING HULHUMALE'
REPUBLIC OF MALDIVES
TEL: +(960)3353535, FAX +(960)3358892
EMAIL: planning@hdc.com.mv

VINARES COMMERCIAL
SEWER PROVISION
HULHUMALE'

The drawings, concept and design contained are the properties of HDC. Use of any kind or copy of whole or part of this drawing, concept or design or use on other projects or sites other than that specified on this drawing is strictly prohibited.


DOCUMENT ID	XXXXX-SSSS-YYYY-(NUMBER)	VERSION	1
DOCUMENT NAME	VINARES GARBAGE ROOM DRAINAGE	REVISION	-
AUTHOR	MOHAMED NAIL	CREATED DATE	21/01/2024
LAST UPDATED BY	MOHAMED NAIL	LAST UPDATED DATE	03/04/2024
REVIEWED BY	GEORGE	REVIEWED DATE	03/04/2024
APPROVED BY	MOHAMED YAMIN	APPROVED DATE	16/07/2023
INFORMATION CLASSIFICATION SCHEME	(Public, Open, Confidential, Confidential & Sensitive and Secret)		

REVISION HISTORY			
VER.	DATE	REV.	REVISION
X	DD/MM/YYYY	Z	(DRAFT)
X	DD/MM/YYYY	Z	(FEEDBACK FORMS INCLUDED)
X	DD/MM/YYYY	Z	(MODIFIED FEEDBACK FORMS)
X	DD/MM/YYYY	Z	(REFORMATTED FEEDBACK FORM)

ARCHITECT	NAIL
STRUCTURAL ENG.	YAMIN
MECHANICAL ENG.	GEORGE
ELECTRICAL ENG.	NAME
SCALE	AS GIVEN

SHEET CONTENT

SHEET NO.
A06

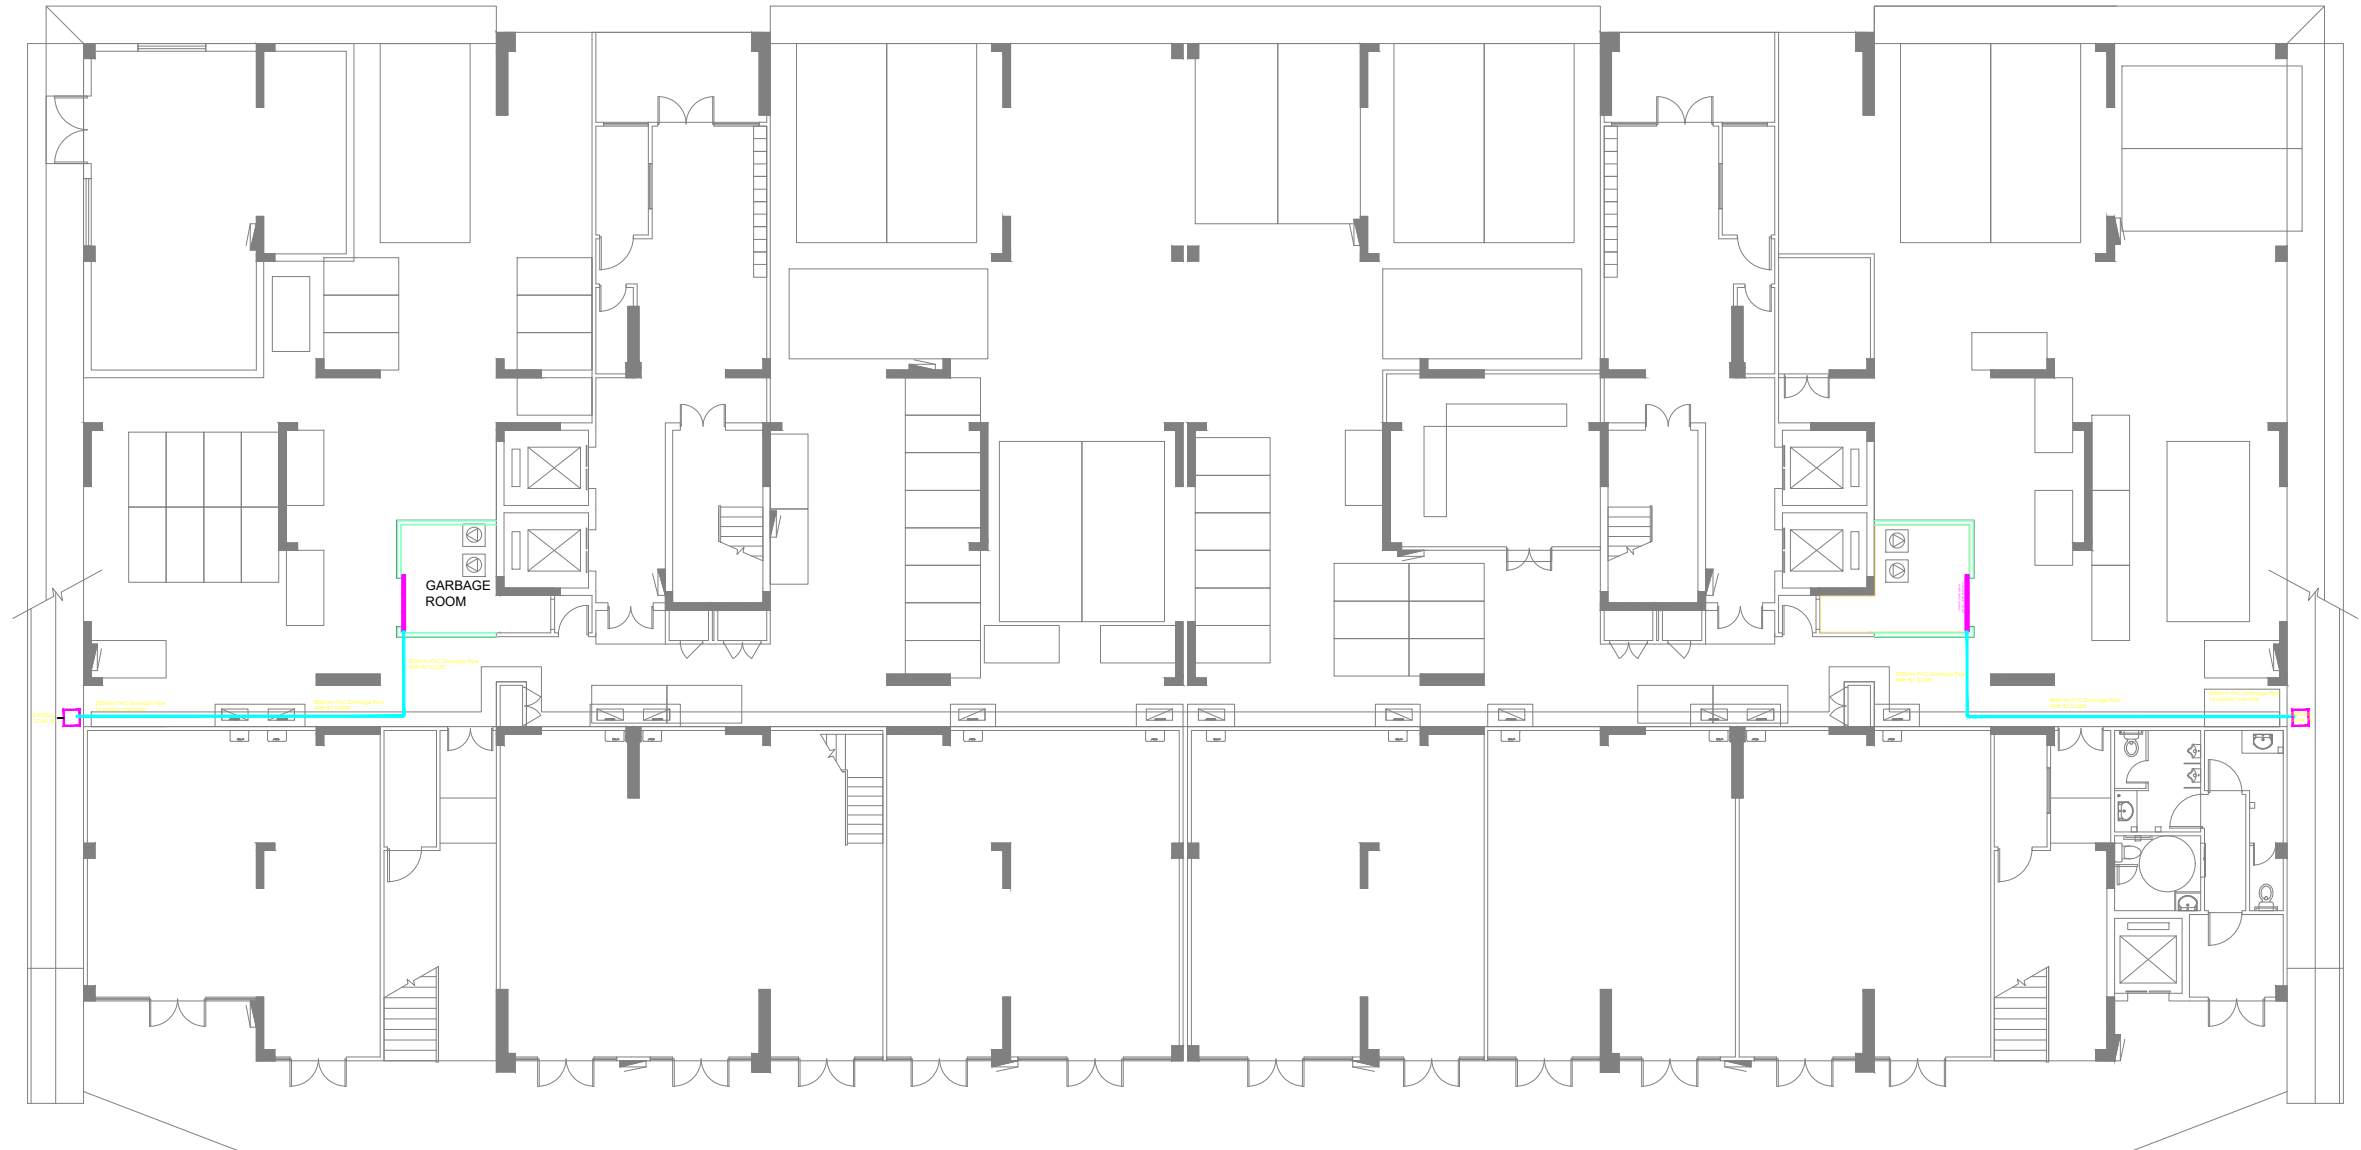

SYMBOL	DESCRIPTION
	DRAINAGE LINE - PVC LOW PRESSURE
	LINEAR FLOOR DRAIN- LxWd: 1500x150x125mm
	EXISTING SOAK PIT

AS-BUILT OF GROUND FLOOR PLAN - BUILDING V6

SCALE 1:200



PLANNING AND DEVELOPMENT DEPARTMENT
THIRD FLOOR, HDC BUILDING HULHUMALE'
REPUBLIC OF MALDIVES
TEL. +(960)3353535, FAX +(960)3358892
EMAIL : planning@hdc.com.mv

VINARES COMMERCIAL SEWER PROVISION HULHUMALE'

The drawings, concept and design contained are the properties of HDC. Use of any kind or copy of whole or part of this drawing, concept or design or use on other projects or sites other than that specified on this drawing is strictly prohibited.


DOCUMENT ID	XXXX-SSSS-YYYY-(NUMBER)	VERSION	1
DOCUMENT NAME	VINARES GARBAGE ROOM DRAINAGE	REVISION	-
AUTHOR	MOHAMED NAIL	CREATED DATE	21/01/2024
LAST UPDATED BY	MOHAMED NAIL	LAST UPDATED DATE	03/04/2024
REVIEWED BY	GEORGE	REVIEWED DATE	03/04/2024
APPROVED BY	MOHAMED YAMIN	APPROVED DATE	16/07/2023
INFORMATION CLASSIFICATION SCHEME	(Public, Open, Confidential, Confidential & Sensitive and Secret)		

REVISION HISTORY			
VER.	DATE	REV.	REVISION
X	DD/MM/YYYY	Z	(DRAFT)
X	DD/MM/YYYY	Z	(FEEDBACK FORMS INCLUDED)
X	DD/MM/YYYY	Z	(MODIFIED FEEDBACK FORMS)
X	DD/MM/YYYY	Z	(REFORMATTED FEEDBACK FORM)

ARCHITECT	NAIL
STRUCTURAL ENG.	YAMIN
MECHANICAL ENG.	GEORGE
ELECTRICAL ENG.	NAME
SCALE	AS GIVEN

SHEET CONTENT

SHEET NO.
A07

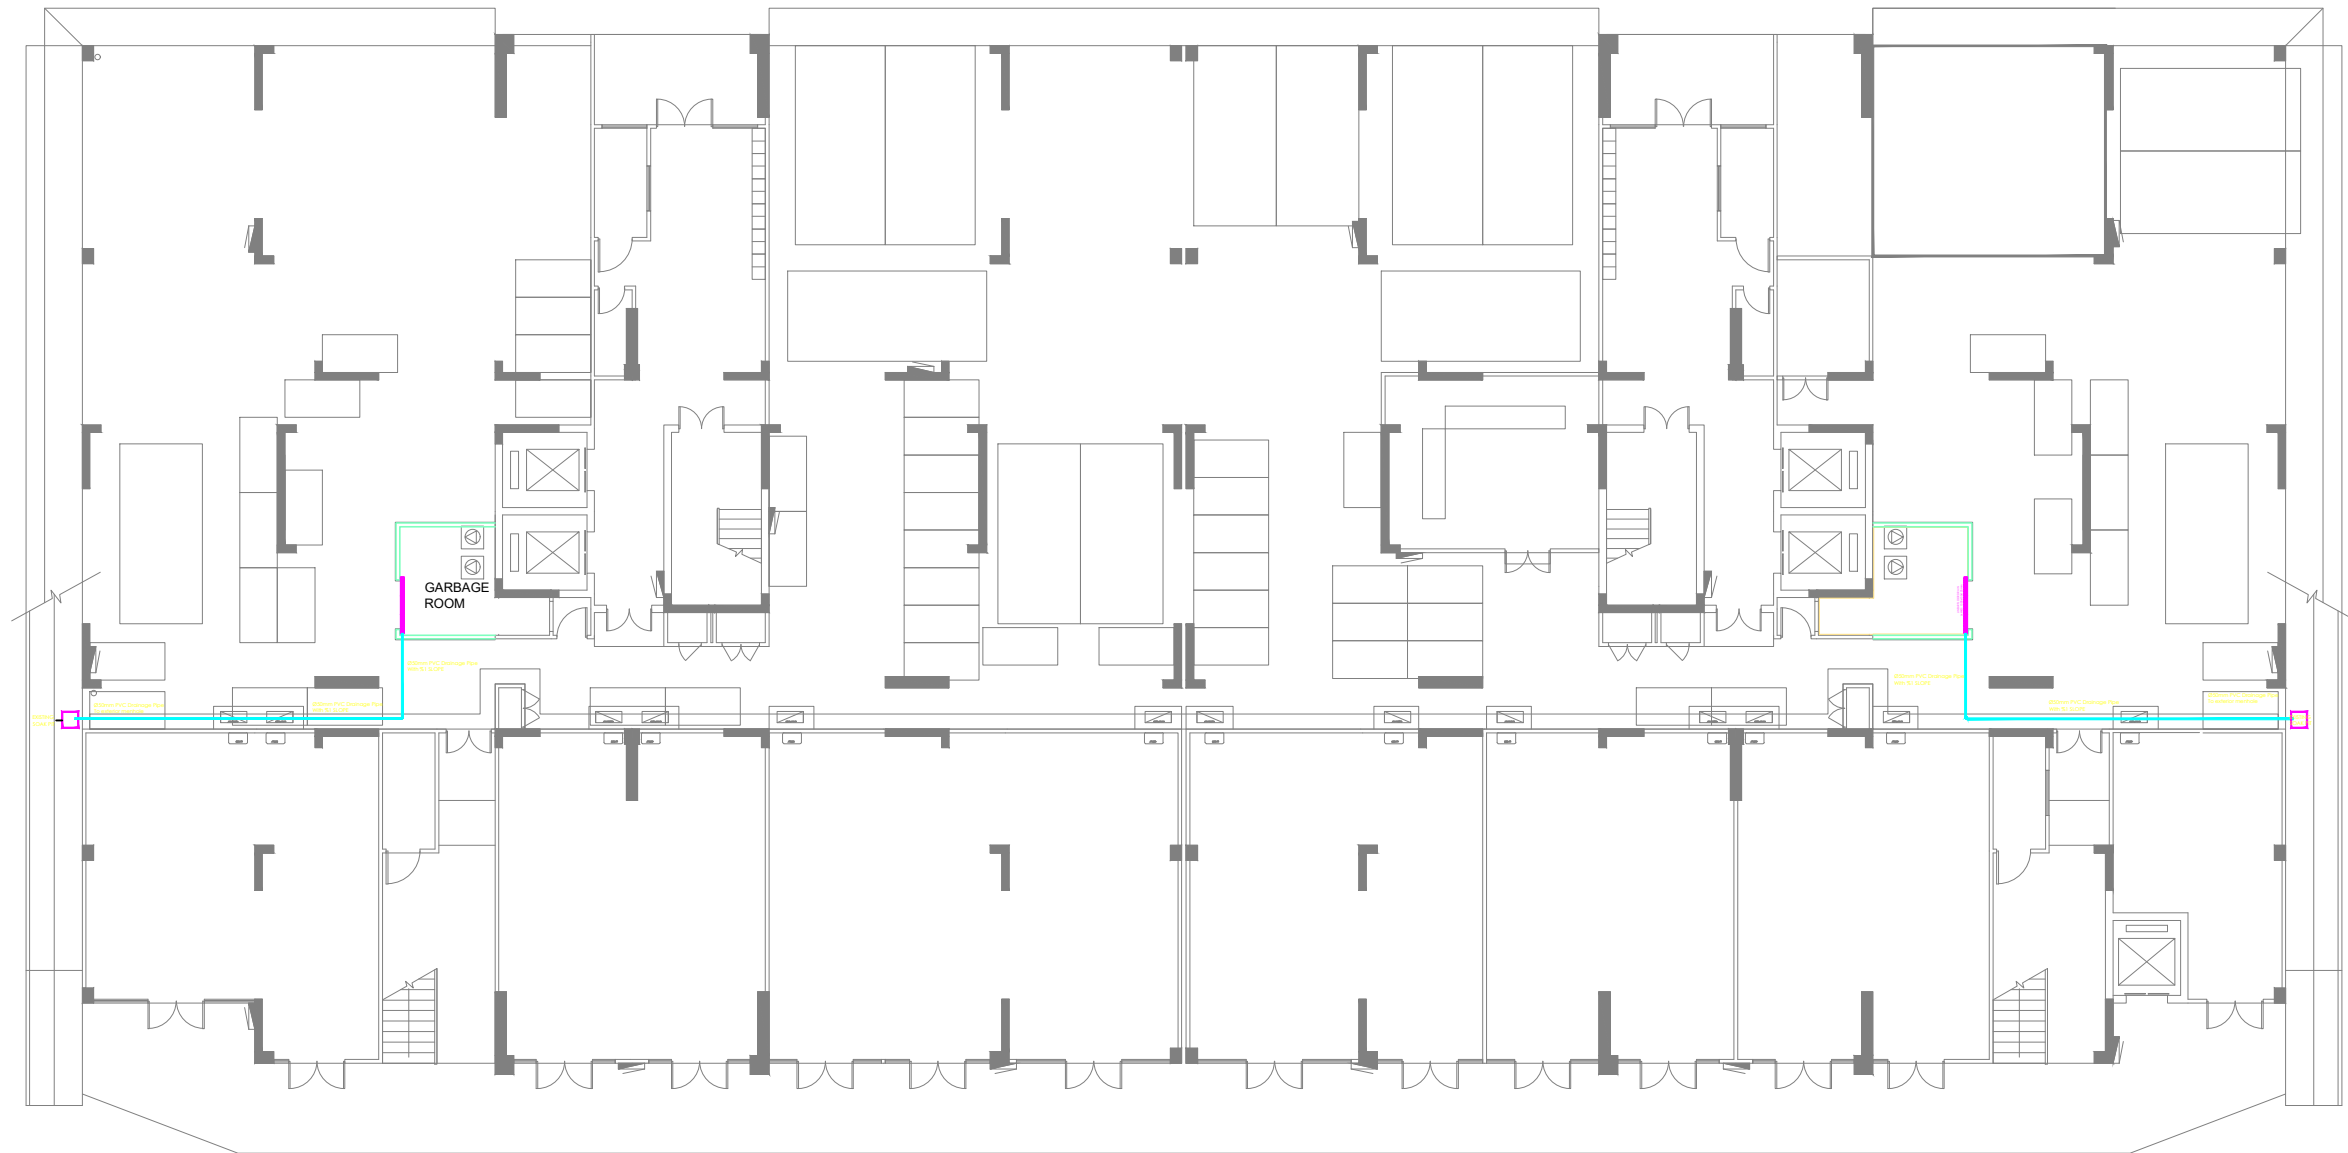

SYMBOL	DESCRIPTION
	DRAINAGE LINE - PVC LOW PRESSURE
	LINEAR FLOOR DRAIN- LxWxD: 1500x150x125mm
	EXISTING SOAK PIT

AS-BUILT OF GROUND FLOOR PLAN - BUILDING V7

SCALE 1:200



PLANNING AND DEVELOPMENT DEPARTMENT
THIRD FLOOR, HDC BUILDING HULHUMALE'
REPUBLIC OF MALDIVES
TEL. +(960)3353535, FAX +(960)3358892
EMAIL : planning@hdc.com.mv

VINARES COMMERCIAL SEWER PROVISION HULHUMALE'

The drawings, concept and design contained are the properties of HDC. Use of any kind or copy of whole or part of this drawing, concept or design or use on other projects or sites other than that specified on this drawing is strictly prohibited.

DOCUMENT ID	XXXXX-SSSSS-YYYY-(NUMBER)	VERSION	1
DOCUMENT NAME	VINARES GARBAGE ROOM DRAINAGE	REVISION	-
AUTHOR	MOHAMED NAIL	CREATED DATE	21/01/2024
LAST UPDATED BY	MOHAMED NAIL	LAST UPDATED DATE	03/04/2024
REVIEWED BY	GEORGE	REVIEWED DATE	03/04/2024
APPROVED BY	MOHAMED YAMIN	APPROVED DATE	16/07/2023
INFORMATION CLASSIFICATION SCHEME	(Public, Open, Confidential, Confidential & Sensitive and Secret)		

REVISION HISTORY			
VER.	DATE	REV.	REVISION
X	DD/MM/YYYY	Z	(DRAFT)
X	DD/MM/YYYY	Z	(FEEDBACK FORMS INCLUDED)
X	DD/MM/YYYY	Z	(MODIFIED FEEDBACK FORMS)
X	DD/MM/YYYY	Z	(REFORMATTED FEEDBACK FORM)

ARCHITECT	NAIL
STRUCTURAL ENG.	YAMIN
MECHANICAL ENG.	GEORGE
ELECTRICAL ENG.	NAME
SCALE	AS GIVEN

SHEET CONTENT

SHEET NO.

A08



SYMBOL	DESCRIPTION
	DRAINAGE LINE - PVC LOW PRESSURE
	LINEAR FLOOR DRAIN- LxWxD: 1500x150x125mm
	EXISTING SOAK PIT

AS-BUILT OF GROUND FLOOR PLAN - BUILDING V9

SCALE 1:200



PLANNING AND DEVELOPMENT DEPARTMENT
THIRD FLOOR, HDC BUILDING HULHUMALE'
REPUBLIC OF MALDIVES
TEL. +(960)3353535, FAX +(960)3358892
EMAIL : planning@hdc.com.mv

VINARES COMMERCIAL SEWER PROVISION HULHUMALE'

The drawings, concept and design contained are the properties of HDC. Use of any kind or copy of whole or part of this drawing, concept or design or use on other projects or sites other than that specified on this drawing is strictly prohibited.


DOCUMENT ID	XXXXX-SSSSS-YYYY-(NUMBER)	VERSION	1
DOCUMENT NAME	VINARES GARBAGE ROOM DRAINAGE	REVISION	-
AUTHOR	MOHAMED NAIL	CREATED DATE	21/01/2024
LAST UPDATED BY	MOHAMED NAIL	LAST UPDATED DATE	03/04/2024
REVIEWED BY	GEORGE	REVIEWED DATE	03/04/2024
APPROVED BY	MOHAMED YAMIN	APPROVED DATE	16/07/2023
INFORMATION CLASSIFICATION SCHEME	(Public, Open, Confidential, Confidential & Sensitive and Secret)		

REVISION HISTORY			
VER.	DATE	REV.	REVISION
X	DD/MM/YYYY	Z	(DRAFT)
X	DD/MM/YYYY	Z	(FEEDBACK FORMS INCLUDED)
X	DD/MM/YYYY	Z	(MODIFIED FEEDBACK FORMS)
X	DD/MM/YYYY	Z	(REFORMATTED FEEDBACK FORM)

ARCHITECT		NAIL
STRUCTURAL ENG.	YAMIN	
MECHANICAL ENG.	GEORGE	
ELECTRICAL ENG.	NAME	
SCALE		AS GIVEN

SHEET CONTENT	

SHEET NO.
A09

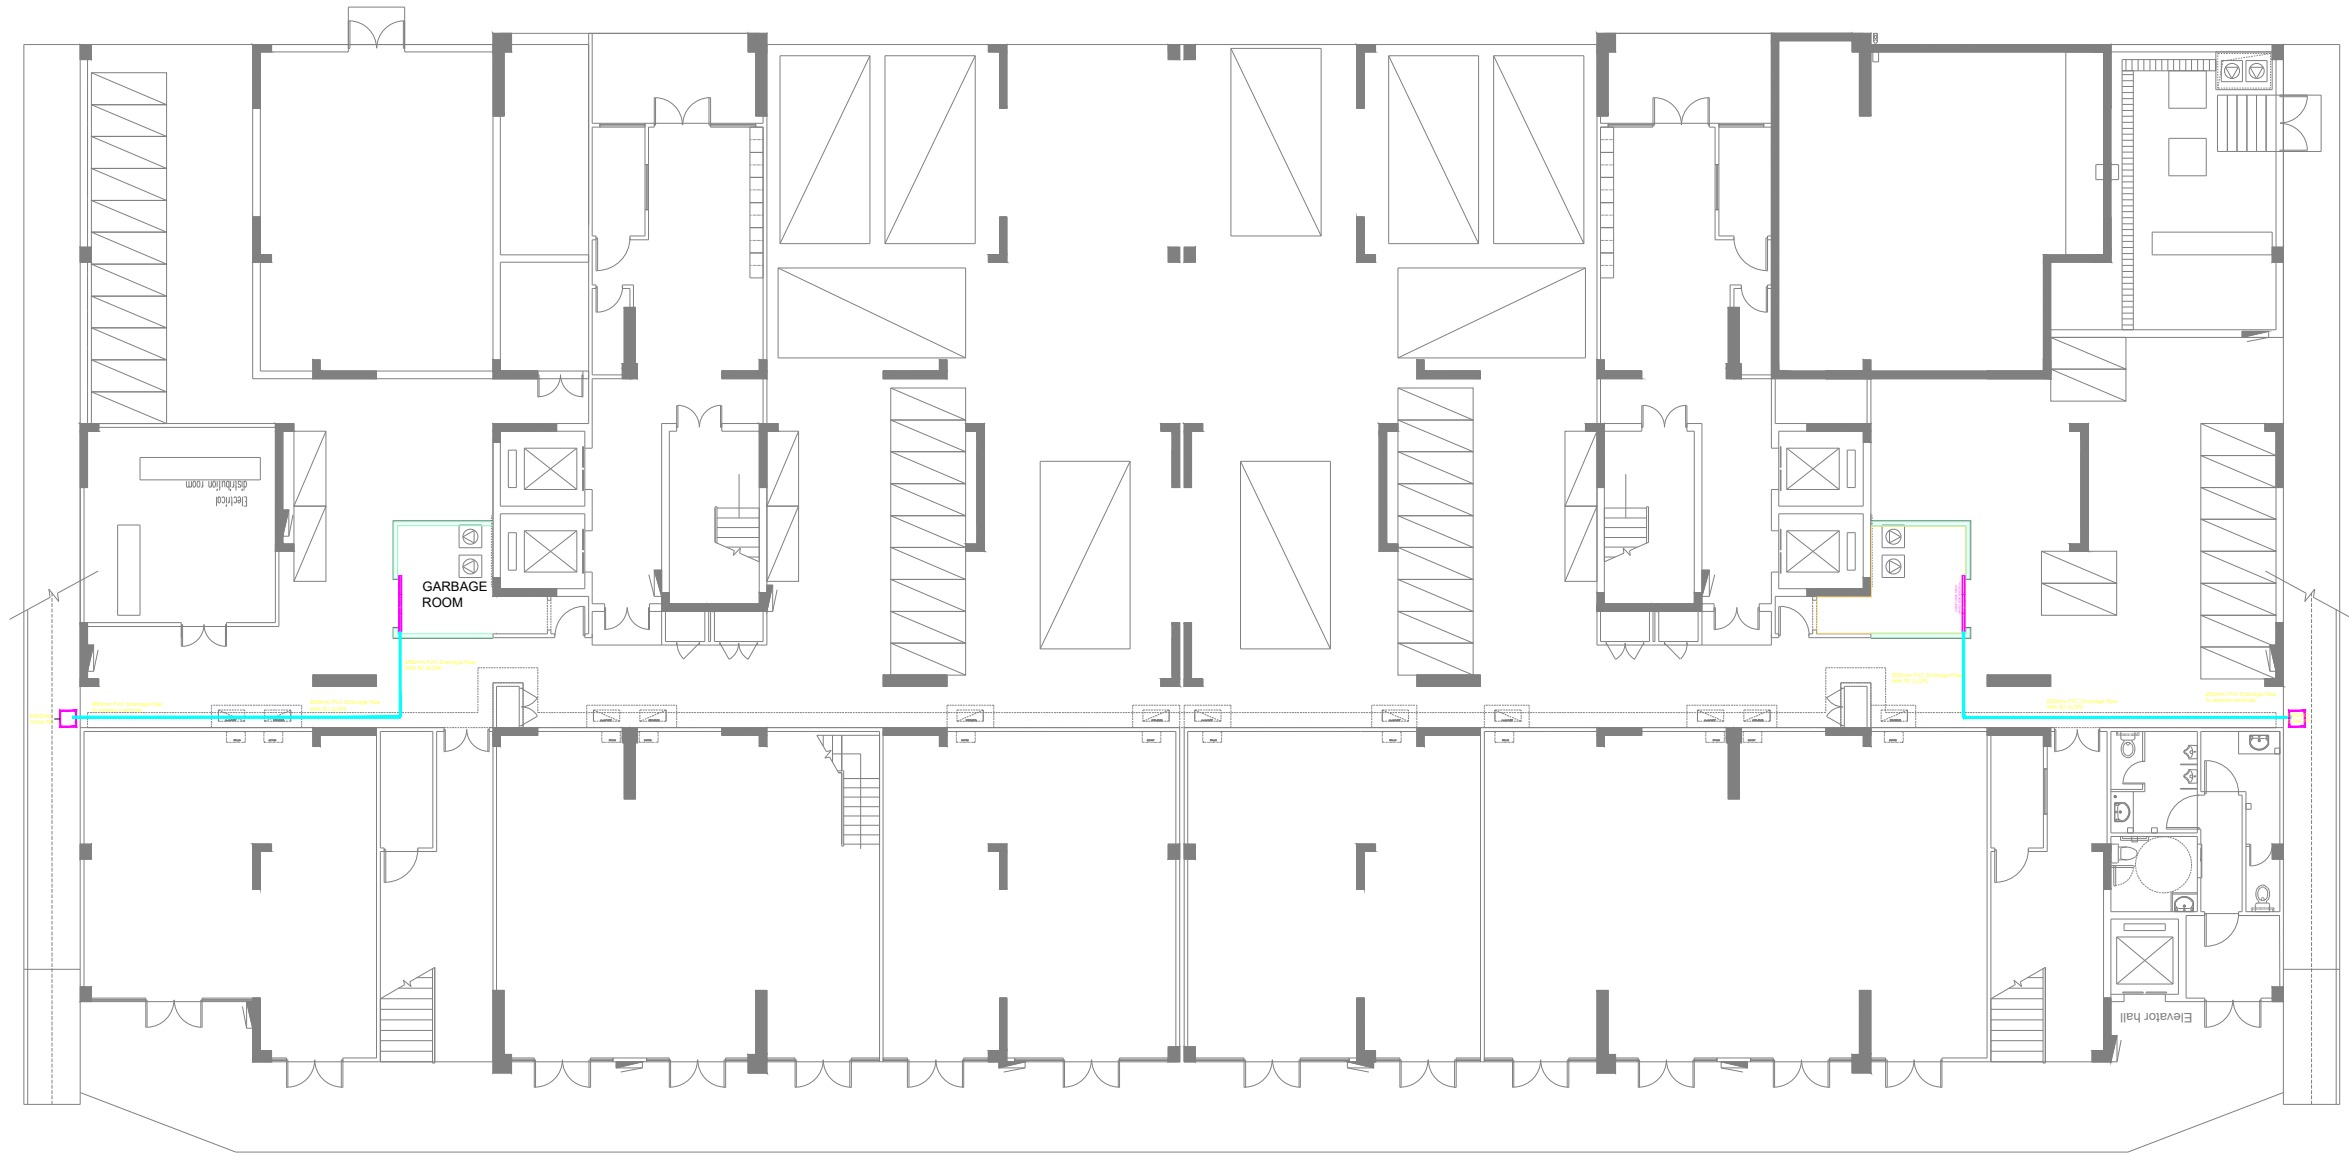

SYMBOL	DESCRIPTION
	DRAINAGE LINE - PVC LOW PRESSURE
	LINEAR FLOOR DRAIN- LxWd: 150x150x125mm
	EXISTING SOAK PIT

AS-BUILT OF GROUND FLOOR PLAN - BUILDING V9

SCALE 1:200



VINARES COMMERCIAL SEWER PROVISION HULHUMALE'

PLANNING AND DEVELOPMENT DEPARTMENT
THIRD FLOOR, HDC BUILDING HULHUMALE'
REPUBLIC OF MALDIVES
TEL. +(960)3353535, FAX +(960)3358892
EMAIL : planning@hdc.com.mv

The drawings, concept and design contained are the properties of HDC. Use of any kind or copy of whole or part of this drawing, concept or design or use on other projects or sites other than that specified on this drawing is strictly prohibited.

DOCUMENT ID	XXXX-SSSS-YYYY-(NUMBER)	VERSION	1
DOCUMENT NAME	VINARES GARBAGE ROOM DRAINAGE	REVISION	-
AUTHOR	MOHAMED NAIL	CREATED DATE	21/01/2024
LAST UPDATED BY	MOHAMED NAIL	LAST UPDATED DATE	03/04/2024
REVIEWED BY	GEORGE	REVIEWED DATE	03/04/2024
APPROVED BY	MOHAMED YAMIN	APPROVED DATE	16/07/2023
INFORMATION CLASSIFICATION SCHEME	(Public, Open, Confidential, Confidential & Sensitive and Secret)		


REVISION HISTORY			
VER.	DATE	REV.	REVISION
X	DD/MM/YYYY	Z	(DRAFT)
X	DD/MM/YYYY	Z	(FEEDBACK FORMS INCLUDED)
X	DD/MM/YYYY	Z	(MODIFIED FEEDBACK FORMS)
X	DD/MM/YYYY	Z	(REFORMATTED FEEDBACK FORM)

ARCHITECT	NAIL
STRUCTURAL ENG.	YAMIN
MECHANICAL ENG.	GEORGE
ELECTRICAL ENG.	NAME
SCALE	AS GIVEN

SHEET CONTENT

SHEET NO.

A10

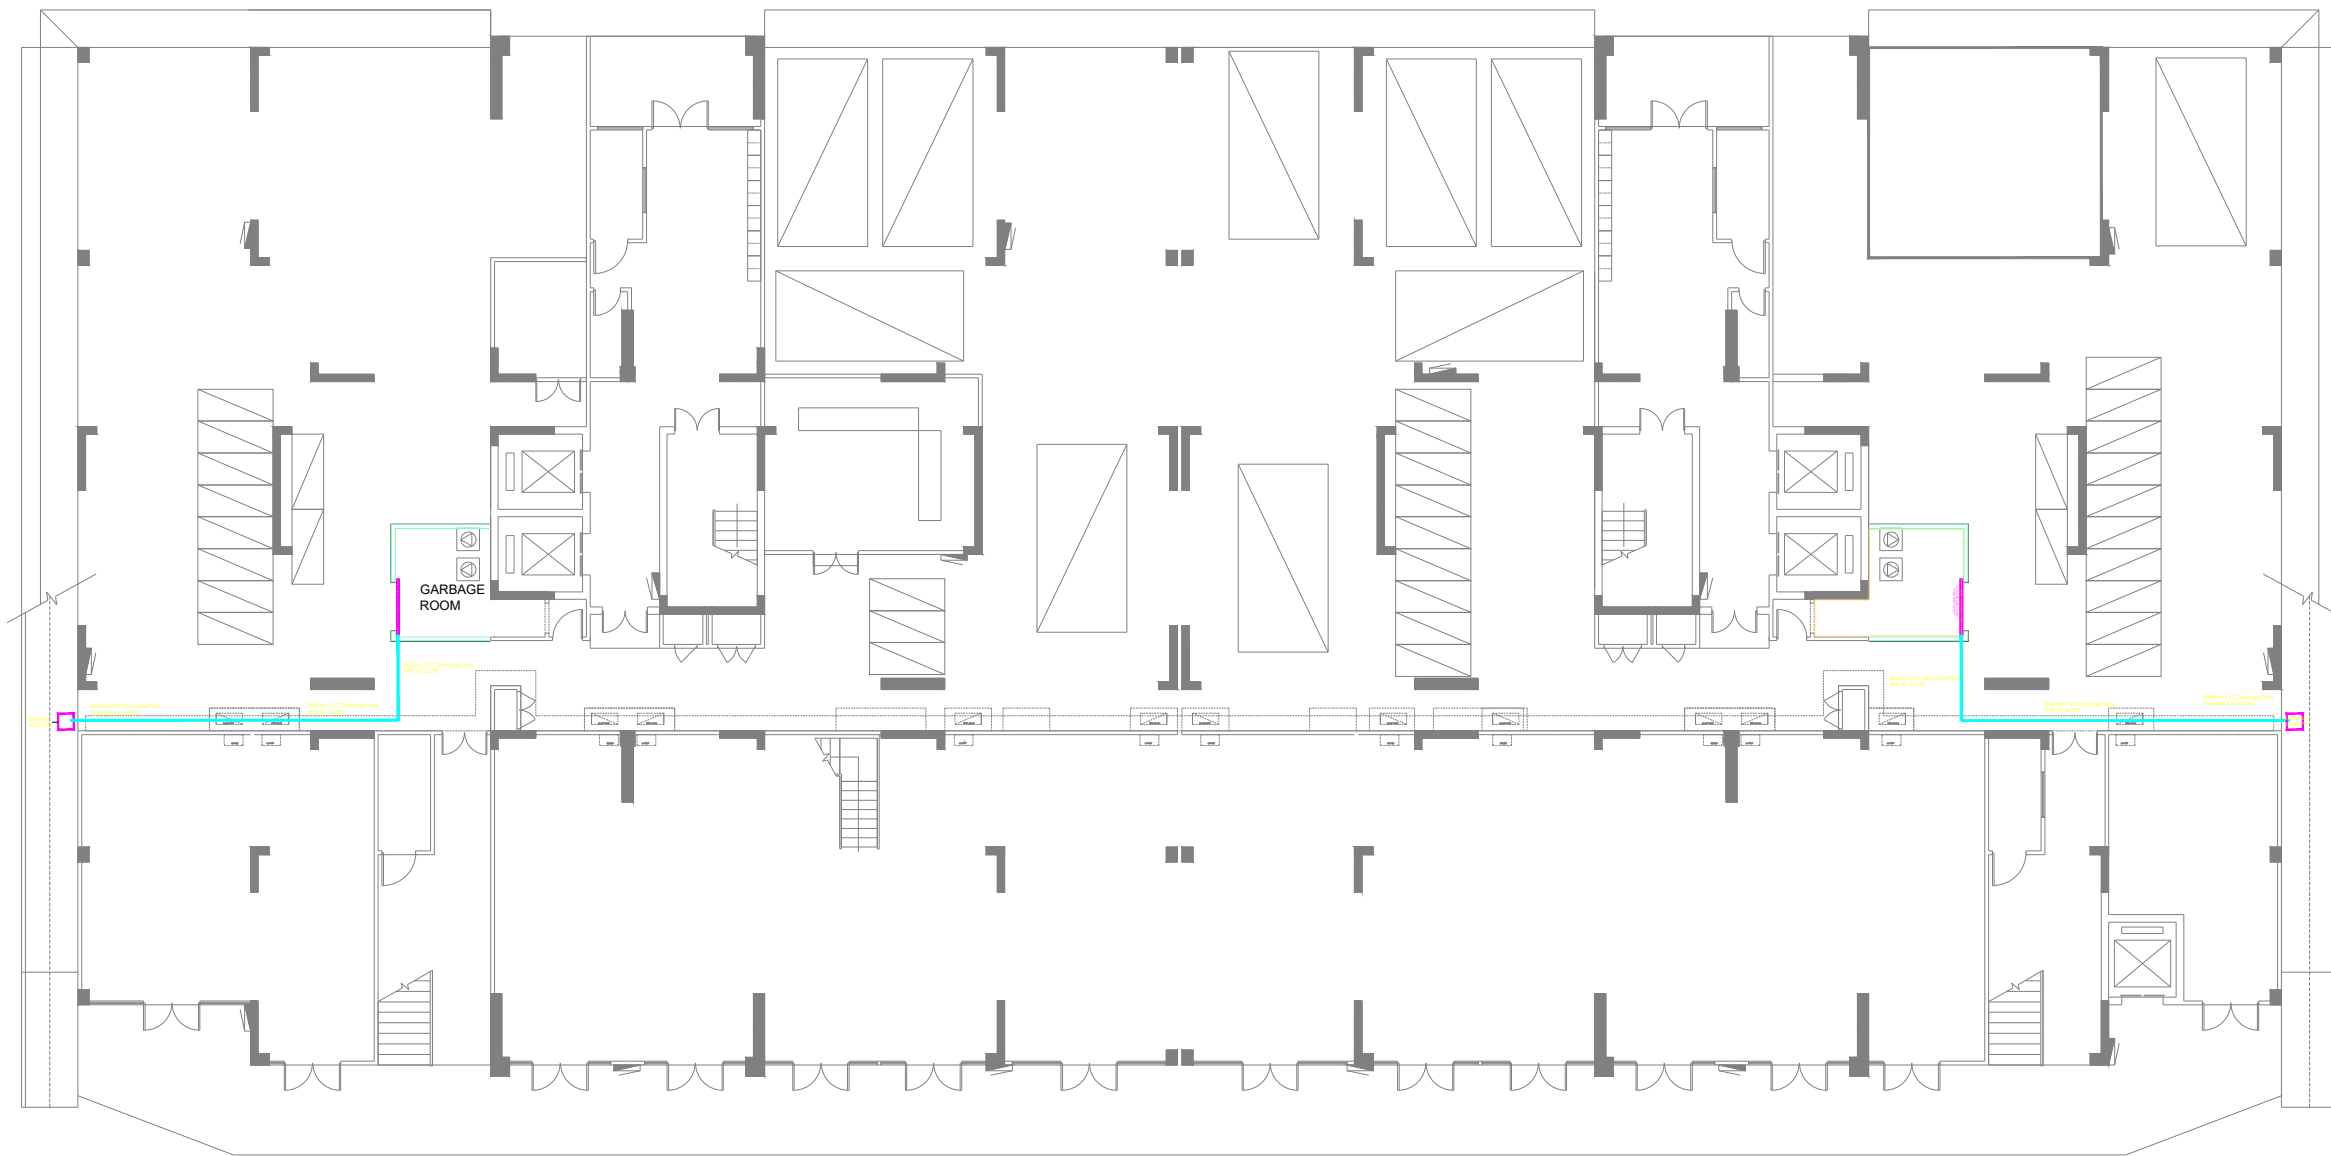

SYMBOL	DESCRIPTION
	DRAINAGE LINE - PVC LOW PRESSURE
	LINEAR FLOOR DRAIN- LxWxH: 1500x150x125mm
	EXISTING SOAK PIT

AS-BUILT OF GROUND FLOOR PLAN - BUILDING V10

SCALE 1:200



PLANNING AND DEVELOPMENT DEPARTMENT
THIRD FLOOR, HDC BUILDING HULHUMALE'
REPUBLIC OF MALDIVES
TEL. +(960)3353535, FAX +(960)3358892
EMAIL : planning@hdc.com.mv

VINARES COMMERCIAL SEWER PROVISION HULHUMALE'

The drawings, concept and design contained are the properties of HDC. Use of any kind or copy of whole or part of this drawing, concept or design or use on other projects or sites other than that specified on this drawing is strictly prohibited.

DOCUMENT ID	XXXX-SSSS-YYYY-(NUMBER)	VERSION	1
DOCUMENT NAME	VINARES GARBAGE ROOM DRAINAGE	REVISION	-
AUTHOR	MOHAMED NAIL	CREATED DATE	21/01/2024
LAST UPDATED BY	MOHAMED NAIL	LAST UPDATED DATE	03/04/2024
REVIEWED BY	GEORGE	REVIEWED DATE	03/04/2024
APPROVED BY	MOHAMED YAMIN	APPROVED DATE	16/07/2023
INFORMATION CLASSIFICATION SCHEME	(Public, Open, Confidential, Confidential & Sensitive and Secret)		

REVISION HISTORY			
VER.	DATE	REV.	REVISION
X	DD/MM/YYYY	Z	(DRAFT)
X	DD/MM/YYYY	Z	(FEEDBACK FORMS INCLUDED)
X	DD/MM/YYYY	Z	(MODIFIED FEEDBACK FORMS)
X	DD/MM/YYYY	Z	(REFORMATTED FEEDBACK FORM)

ARCHITECT	NAIL
STRUCTURAL ENG.	YAMIN
MECHANICAL ENG.	GEORGE
ELECTRICAL ENG.	NAME
SCALE	AS GIVEN

SHEET CONTENT

SHEET NO.

A11