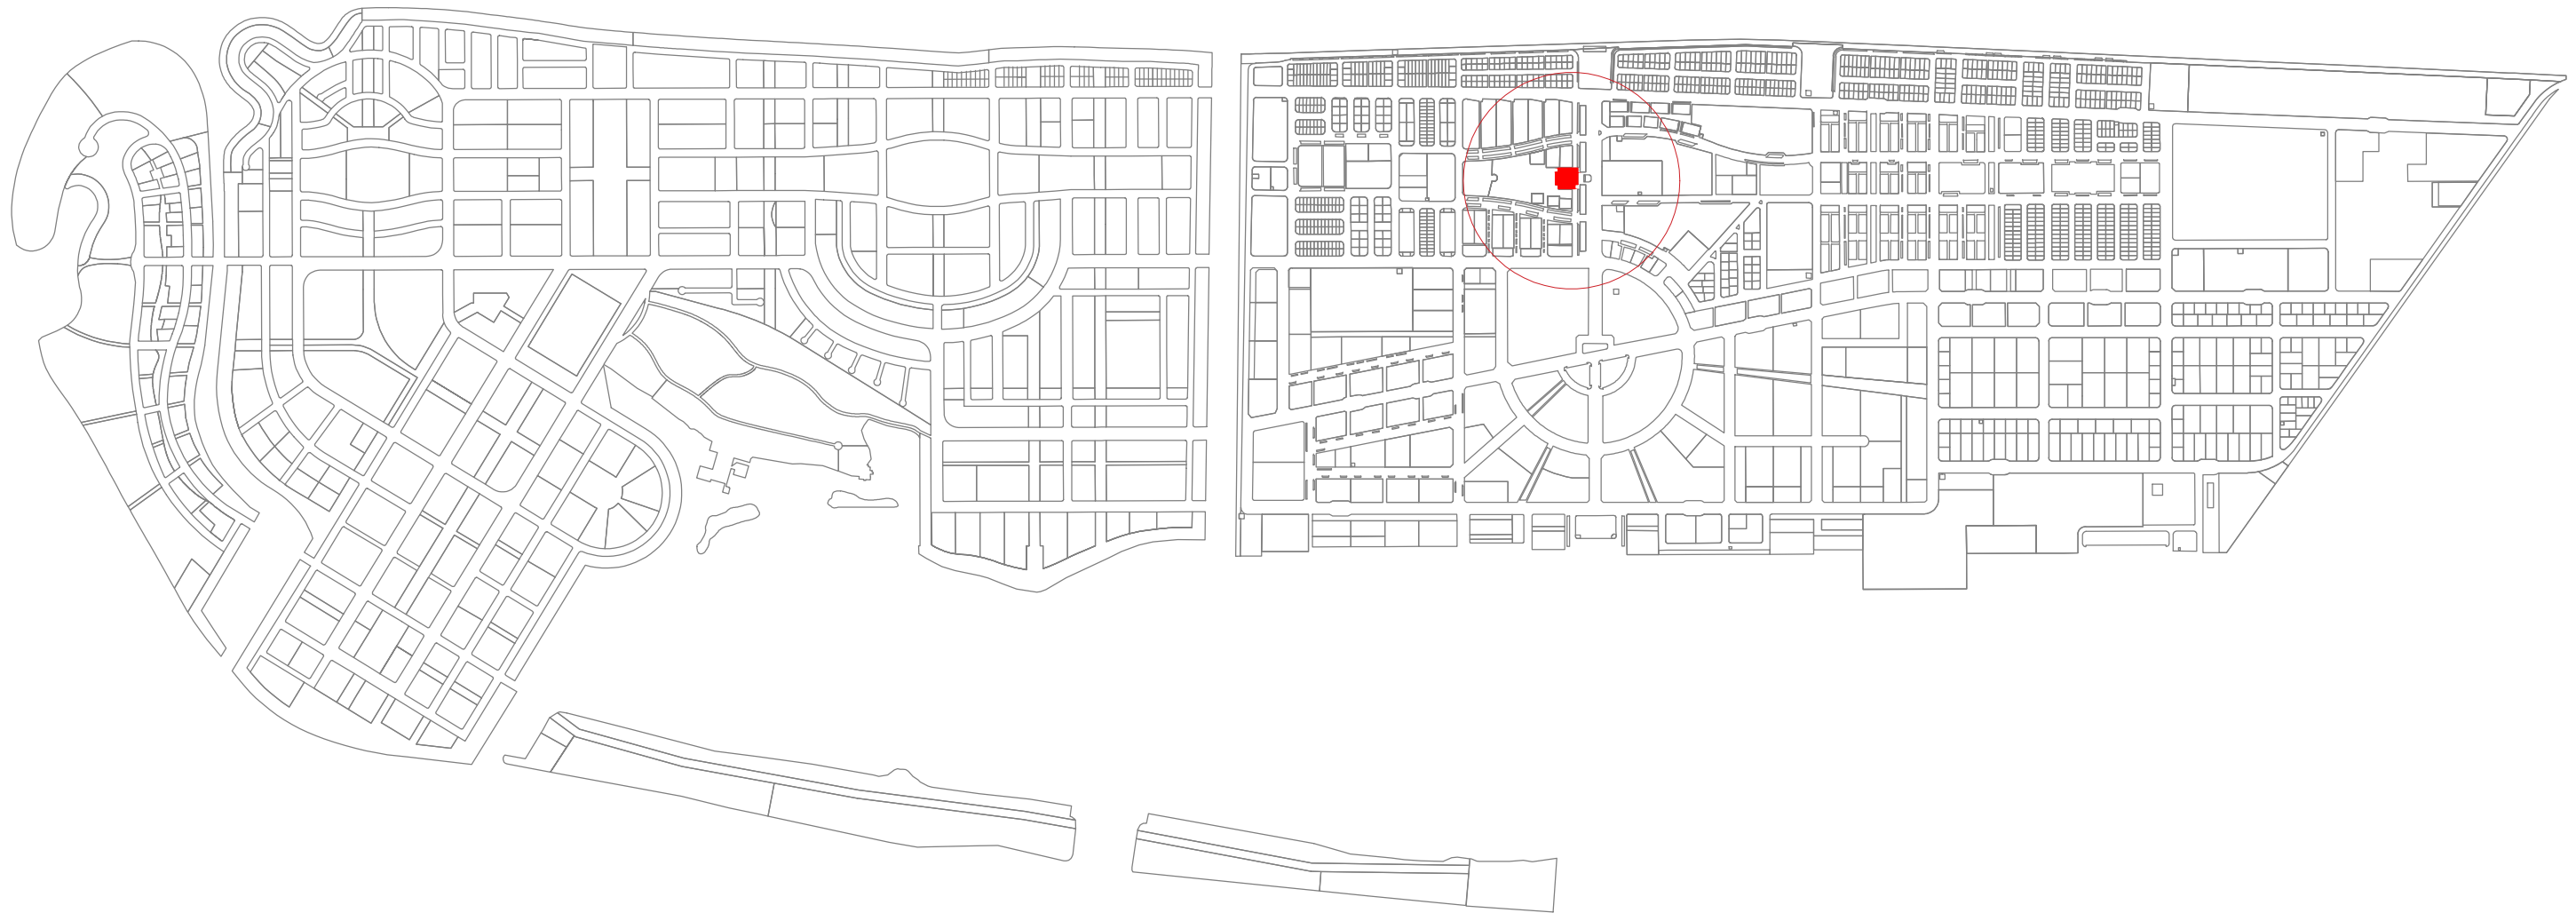


# HDC BUILDING FIRE DRAWING

PROPOSED DESIGNS FOR FIRE PROTECTION  
SERVICES DRAWING  
13 MARCH 2024



HOUSING  
DEVELOPMENT  
CORPORATION



### LOCATION PLAN

SCALE NTS



**HOUSING  
DEVELOPMENT  
CORPORATION**

PLANNING AND DEVELOPMENT DEPARTMENT  
THIRD FLOOR, HDC BUILDING HULHUMALE'  
REPUBLIC OF MALDIVES  
TEL. +(960)3353535, FAX +(960)3358892  
EMAIL : planning@hdc.com.mv

### HDC OFFICE - FIRE PROTECTION HULHUMALE'

The drawings, concept and design contained are the properties of HDC. Use of any kind or copy of whole or part of this drawing, concept or design or use on other projects or sites other than that specified on this drawing is strictly prohibited.

<b>DOCUMENT ID</b>	XXXXX-SSSS-YYYY-(NUMBER)	<b>VERSION</b>	1
<b>DOCUMENT NAME</b>	HDC OFFICE FIRE DRAWING	<b>REVISION</b>	-
<b>AUTHOR</b>	MOHAMED NAIL	<b>CREATED DATE</b>	05/10/2023
<b>LAST UPDATED BY</b>	MOHAMED NAIL	<b>LAST UPDATED DATE</b>	13/03/2024
<b>REVIEWED BY</b>	GEORGE	<b>REVIEWED DATE</b>	13/03/2024
<b>APPROVED BY</b>	MOHAMED YAMIN	<b>APPROVED DATE</b>	05/10/2023
<b>INFORMATION CLASSIFICATION SCHEME</b>	(Public, Open, Confidential, Confidential & Sensitive and Secret)		

REVISION HISTORY			
VER.	DATE	REV.	REVISION
X	DD/MM/YYYY	Z	(DRAFT)
X	DD/MM/YYYY	Z	(FEEDBACK FORMS INCLUDED)
X	DD/MM/YYYY	Z	(MODIFIED FEEDBACK FORMS)
X	DD/MM/YYYY	Z	(REFORMATTED FEEDBACK FORM)






<b>ARCHITECT</b>	Naail
<b>STRUCTURAL ENG.</b>	-
<b>MECHANICAL ENG.</b>	George
<b>ELECTRICAL ENG.</b>	-
<b>SCALE</b>	AS GIVEN

SHEET CONTENT

SHEET NO.  
**A01**



LEGEND:

-  FIRE EXTINGUISHER 6KG DRY CHEMICAL
-  FIRE BLANKET
-  EXISTING LANDING VALVE (DRY RISER SYSTEM)
-  FIRE HOSE REEL
-  EXISTING BREECHING INLET

GROUND FLOOR - FIRE PROTECTION PLAN

SCALE 1:200



PLANNING AND DEVELOPMENT DEPARTMENT  
 THIRD FLOOR, HDC BUILDING HULHUMALE'  
 REPUBLIC OF MALDIVES  
 TEL. +(960)3353535, FAX +(960)3358892  
 EMAIL : planning@hdc.com.mv

HDC OFFICE - FIRE PROTECTION  
 HULHUMALE'

The drawings, concept and design contained are the properties of HDC. Use of any kind or copy of whole or part of this drawing, concept or design or use on other projects or sites other than that specified on this drawing is strictly prohibited.

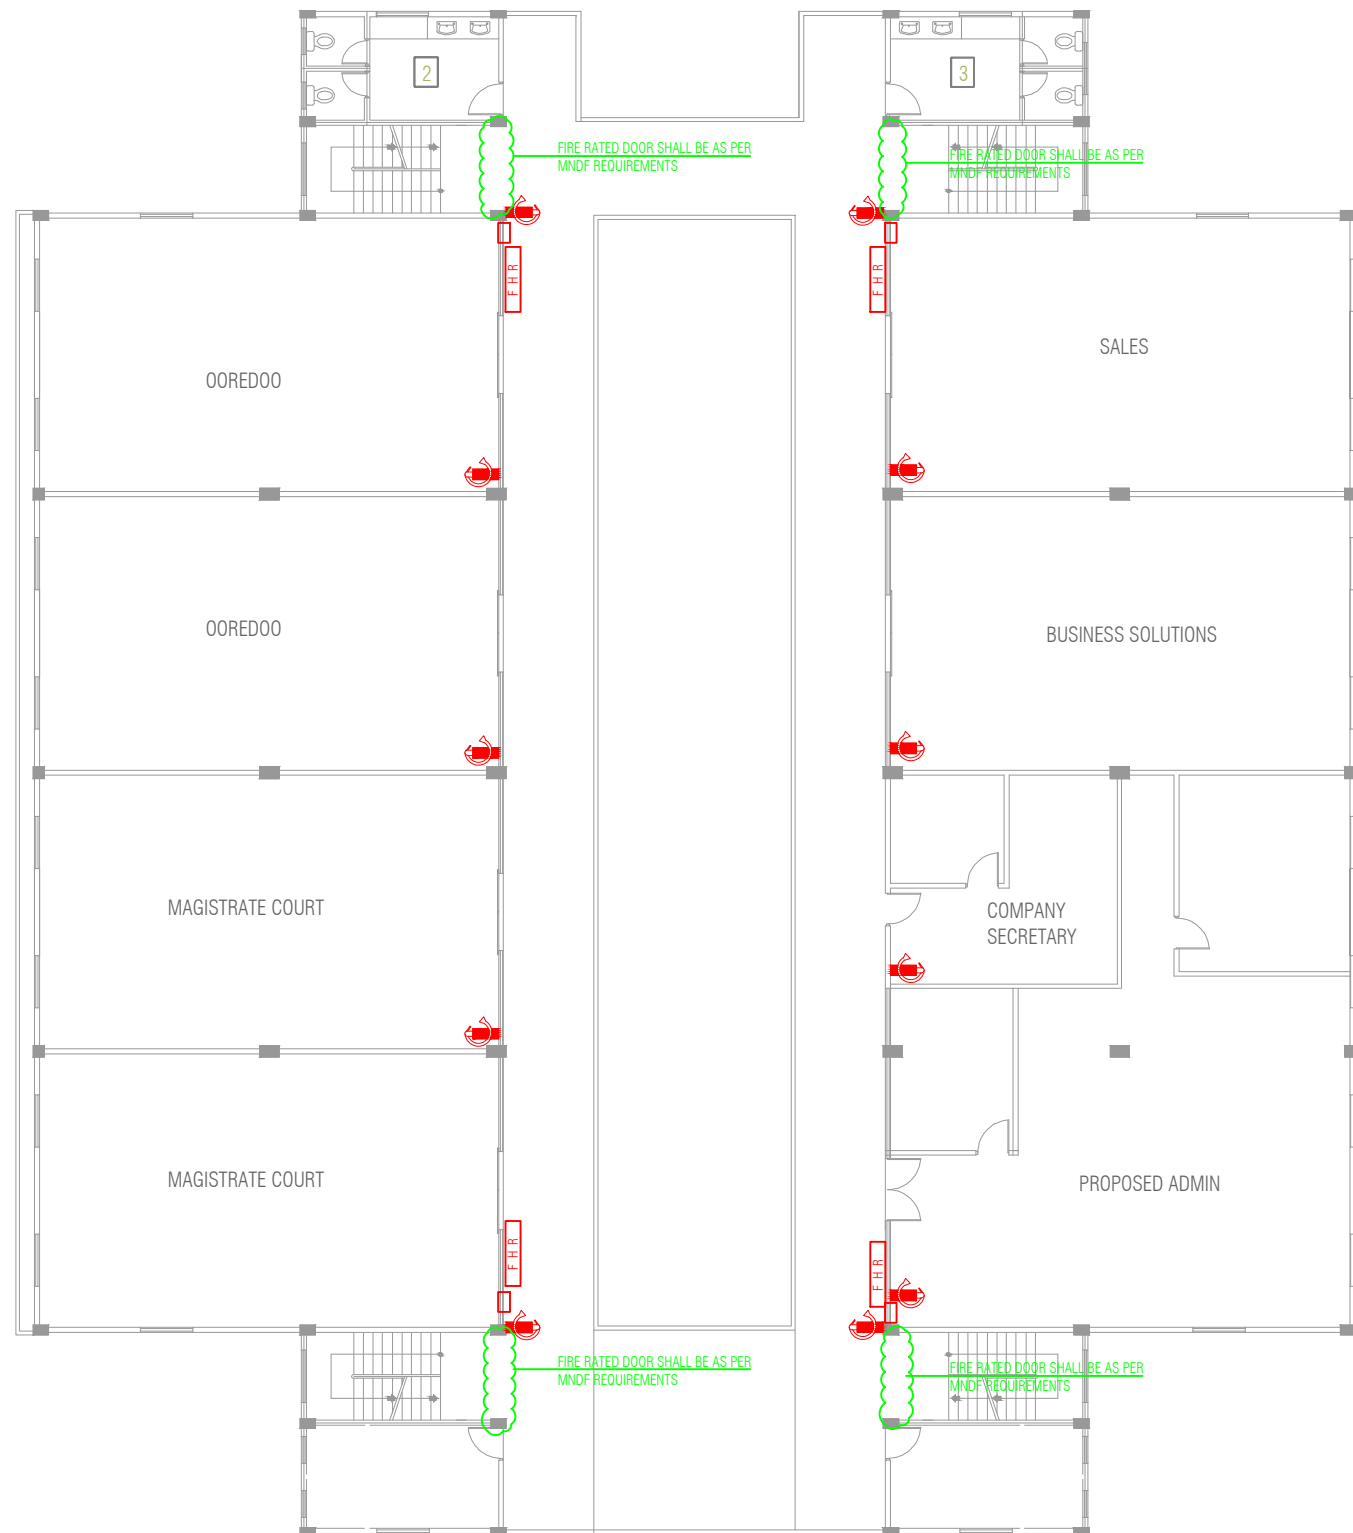
DOCUMENT ID	XXXXX-SSSS-YYYY-(NUMBER)	VERSION	1
DOCUMENT NAME	HDC OFFICE FIRE DRAWING	REVISION	-
AUTHOR	MOHAMED NAIL	CREATED DATE	05/10/2023
LAST UPDATED BY	MOHAMED NAIL	LAST UPDATED DATE	13/03/2024
REVIEWED BY	GEORGE	REVIEWED DATE	13/03/2024
APPROVED BY	MOHAMED YAMIN	APPROVED DATE	05/10/2023
INFORMATION CLASSIFICATION SCHEME	(Public, Open, Confidential, Confidential & Sensitive and Secret)		

REVISION HISTORY			
VER.	DATE	REV.	REVISION
X	DD/MM/YYYY	Z	(DRAFT)
X	DD/MM/YYYY	Z	(FEEDBACK FORMS INCLUDED)
X	DD/MM/YYYY	Z	(MODIFIED FEEDBACK FORMS)
X	DD/MM/YYYY	Z	(REFORMATTED FEEDBACK FORM)






ARCHITECT	Naail
STRUCTURAL ENG.	-
MECHANICAL ENG.	George
ELECTRICAL ENG.	-
SCALE	AS GIVEN

SHEET CONTENT

SHEET NO.	A02
-----------	-----



LEGEND:

-  FIRE EXTINGUISHER 6KG DRY CHEMICAL
-  FIRE BLANKET
-  EXISTING LANDING VALVE (DRY RISER SYSTEM)
-  FIRE HOSE REEL
-  EXISTING BREECHING INLET

FIRST FLOOR FIRE PROTECTION PLAN

SCALE 1:200



PLANNING AND DEVELOPMENT DEPARTMENT  
 THIRD FLOOR, HDC BUILDING HULHUMALE'  
 REPUBLIC OF MALDIVES  
 TEL. +(960)3353535, FAX +(960)3358892  
 EMAIL : planning@hdc.com.mv

HDC OFFICE - FIRE PROTECTION  
 HULHUMALE'

The drawings, concept and design contained are the properties of HDC. Use of any kind or copy of whole or part of this drawing, concept or design or use on other projects or sites other than that specified on this drawing is strictly prohibited.

DOCUMENT ID	XXXXX-SSSS-YYYY-(NUMBER)	VERSION	1
DOCUMENT NAME	HDC OFFICE FIRE DRAWING	REVISION	-
AUTHOR	MOHAMED NAIL	CREATED DATE	05/10/2023
LAST UPDATED BY	MOHAMED NAIL	LAST UPDATED DATE	13/03/2024
REVIEWED BY	GEORGE	REVIEWED DATE	13/03/2024
APPROVED BY	MOHAMED YAMIN	APPROVED DATE	05/10/2023
INFORMATION CLASSIFICATION SCHEME	(Public, Open, Confidential, Confidential & Sensitive and Secret)		

REVISION HISTORY			
VER.	DATE	REV.	REVISION
X	DD/MM/YYYY	Z	(DRAFT)
X	DD/MM/YYYY	Z	(FEEDBACK FORMS INCLUDED)
X	DD/MM/YYYY	Z	(MODIFIED FEEDBACK FORMS)
X	DD/MM/YYYY	Z	(REFORMATTED FEEDBACK FORM)






ARCHITECT	Naail
STRUCTURAL ENG.	-
MECHANICAL ENG.	George
ELECTRICAL ENG.	-
SCALE	AS GIVEN

SHEET CONTENT

SHEET NO.  
**A03**



LEGEND:

-  FIRE EXTINGUISHER 6KG DRY CHEMICAL
-  FIRE BLANKET
-  EXISTING LANDING VALVE (DRY RISER SYSTEM)
-  FIRE HOSE REEL
-  EXISTING BREECHING INLET

SECOND FLOOR FIRE PROTECTION PLAN

SCALE 1:200



PLANNING AND DEVELOPMENT DEPARTMENT  
 THIRD FLOOR, HDC BUILDING HULHUMALE'  
 REPUBLIC OF MALDIVES  
 TEL. +(960)3353535, FAX +(960)3358892  
 EMAIL : planning@hdc.com.mv

HDC OFFICE - FIRE PROTECTION  
 HULHUMALE'

The drawings, concept and design contained are the properties of HDC. Use of any kind or copy of whole or part of this drawing, concept or design or use on other projects or sites other than that specified on this drawing is strictly prohibited.

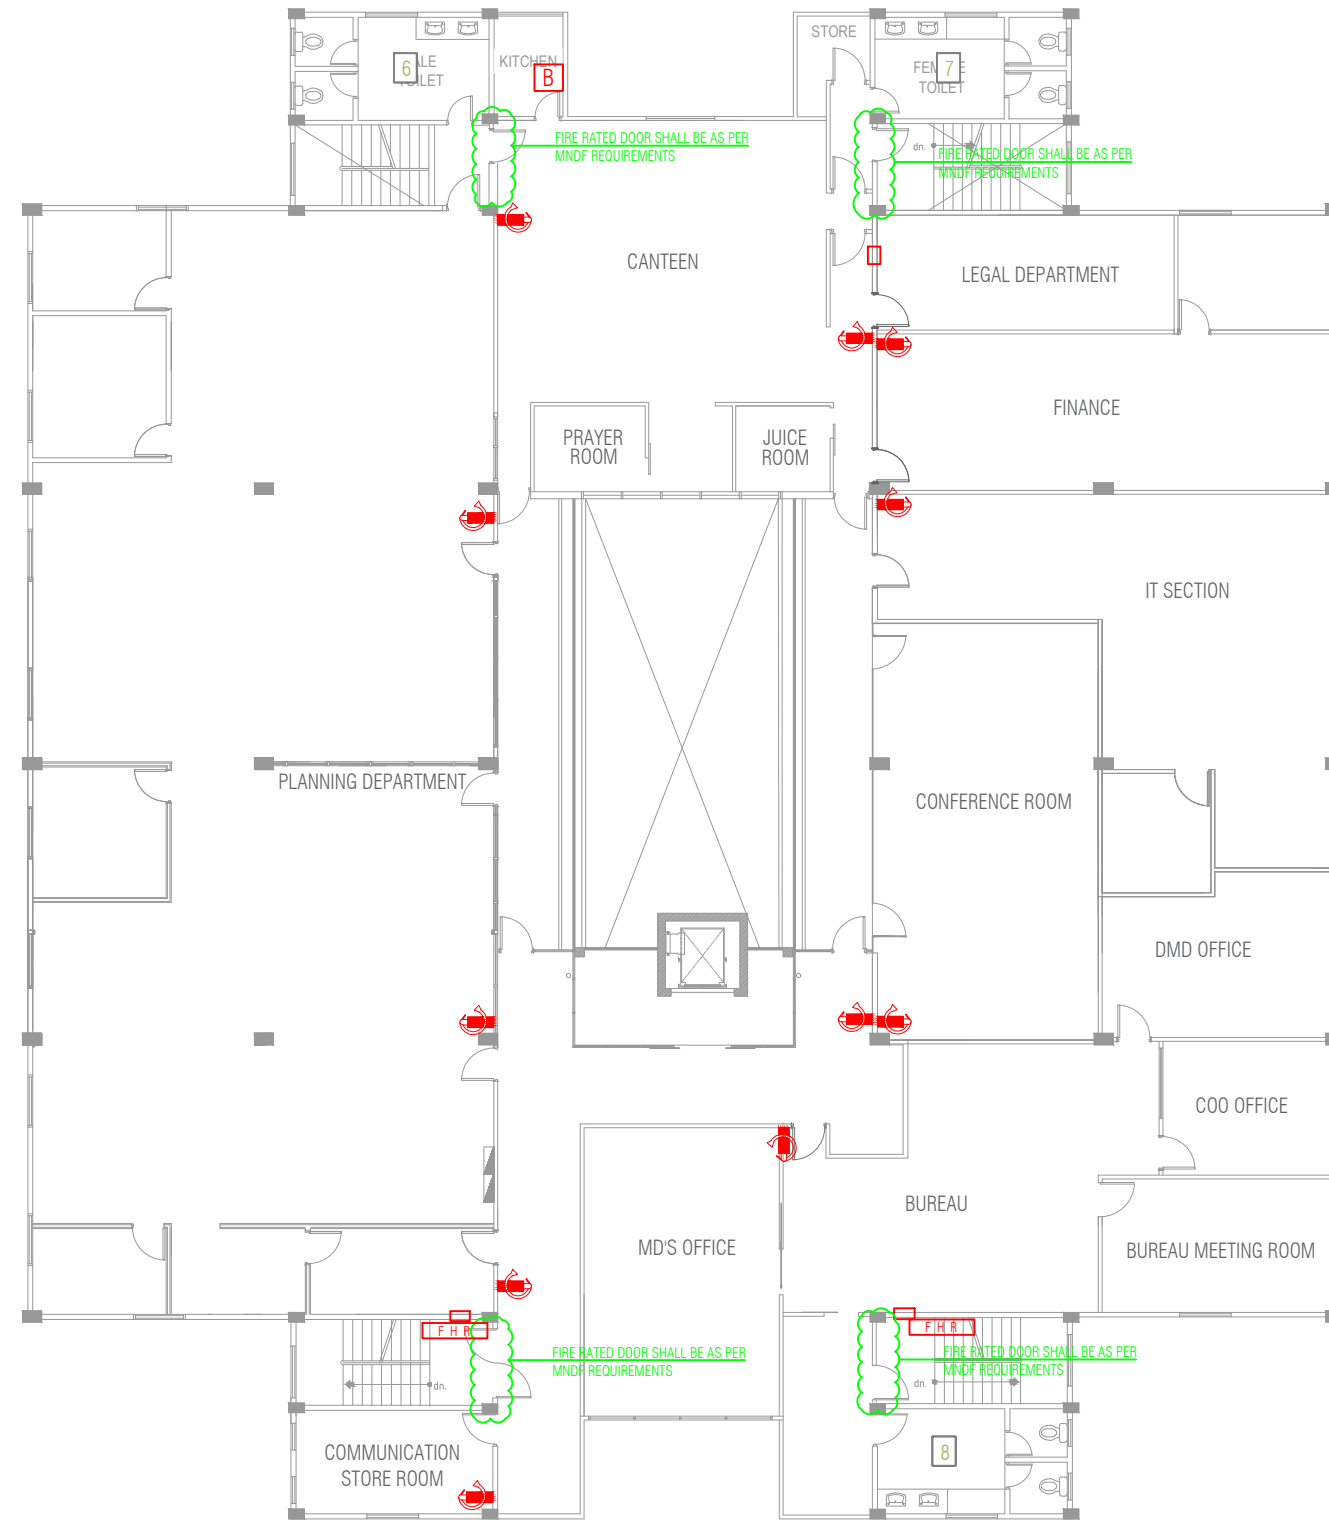
DOCUMENT ID	XXXXX-SSSS-YYYY-(NUMBER)	VERSION	1
<b>DOCUMENT NAME</b>	HDC OFFICE FIRE DRAWING	<b>REVISION</b>	-
<b>AUTHOR</b>	MOHAMED NAIL	<b>CREATED DATE</b>	05/10/2023
<b>LAST UPDATED BY</b>	MOHAMED NAIL	<b>LAST UPDATED DATE</b>	13/03/2024
<b>REVIEWED BY</b>	GEORGE	<b>REVIEWED DATE</b>	13/03/2024
<b>APPROVED BY</b>	MOHAMED YAMIN	<b>APPROVED DATE</b>	05/10/2023
<b>INFORMATION CLASSIFICATION SCHEME</b>	(Public, Open, Confidential, Confidential & Sensitive and Secret)		






REVISION HISTORY			
VER.	DATE	REV.	REVISION
X	DD/MM/YYYY	Z	(DRAFT)
X	DD/MM/YYYY	Z	(FEEDBACK FORMS INCLUDED)
X	DD/MM/YYYY	Z	(MODIFIED FEEDBACK FORMS)
X	DD/MM/YYYY	Z	(REFORMATTED FEEDBACK FORM)

<b>ARCHITECT</b>	Naail
<b>STRUCTURAL ENG.</b>	-
<b>MECHANICAL ENG.</b>	George
<b>ELECTRICAL ENG.</b>	-
<b>SCALE</b>	AS GIVEN

SHEET CONTENT

SHEET NO.  
**A04**



- LEGEND:
-  FIRE EXTINGUISHER 6KG DRY CHEMICAL
  -  FIRE BLANKET
  -  EXISTING LANDING VALVE (DRY RISER SYSTEM)
  -  FIRE HOSE REEL
  -  EXISTING BREECHING INLET

**THIRD FLOOR FIRE PROTECTION PLAN**  
 SCALE 1:200  


**HDC OFFICE - FIRE PROTECTION**  
 HULHUMALE'

The drawings, concept and design contained are the properties of HDC. Use of any kind or copy of whole or part of this drawing, concept or design or use on other projects or sites other than that specified on this drawing is strictly prohibited.

<b>DOCUMENT ID</b>	XXXXX-SSSS-YYYY-(NUMBER)	<b>VERSION</b>	1
<b>DOCUMENT NAME</b>	HDC OFFICE FIRE DRAWING	<b>REVISION</b>	-
<b>AUTHOR</b>	MOHAMED NAIL	<b>CREATED DATE</b>	05/10/2023
<b>LAST UPDATED BY</b>	MOHAMED NAIL	<b>LAST UPDATED DATE</b>	13/03/2024
<b>REVIEWED BY</b>	GEORGE	<b>REVIEWED DATE</b>	13/03/2024
<b>APPROVED BY</b>	MOHAMED YAMIN	<b>APPROVED DATE</b>	05/10/2023
<b>INFORMATION CLASSIFICATION SCHEME</b>	(Public, Open, Confidential, Confidential & Sensitive and Secret)		

REVISION HISTORY			
VER.	DATE	REV.	REVISION
X	DD/MM/YYYY	Z	(DRAFT)
X	DD/MM/YYYY	Z	(FEEDBACK FORMS INCLUDED)
X	DD/MM/YYYY	Z	(MODIFIED FEEDBACK FORMS)
X	DD/MM/YYYY	Z	(REFORMATTED FEEDBACK FORM)

<b>ARCHITECT</b>	Naail
<b>STRUCTURAL ENG.</b>	-
<b>MECHANICAL ENG.</b>	George
<b>ELECTRICAL ENG.</b>	-
<b>SCALE</b>	AS GIVEN

<b>SHEET CONTENT</b>